


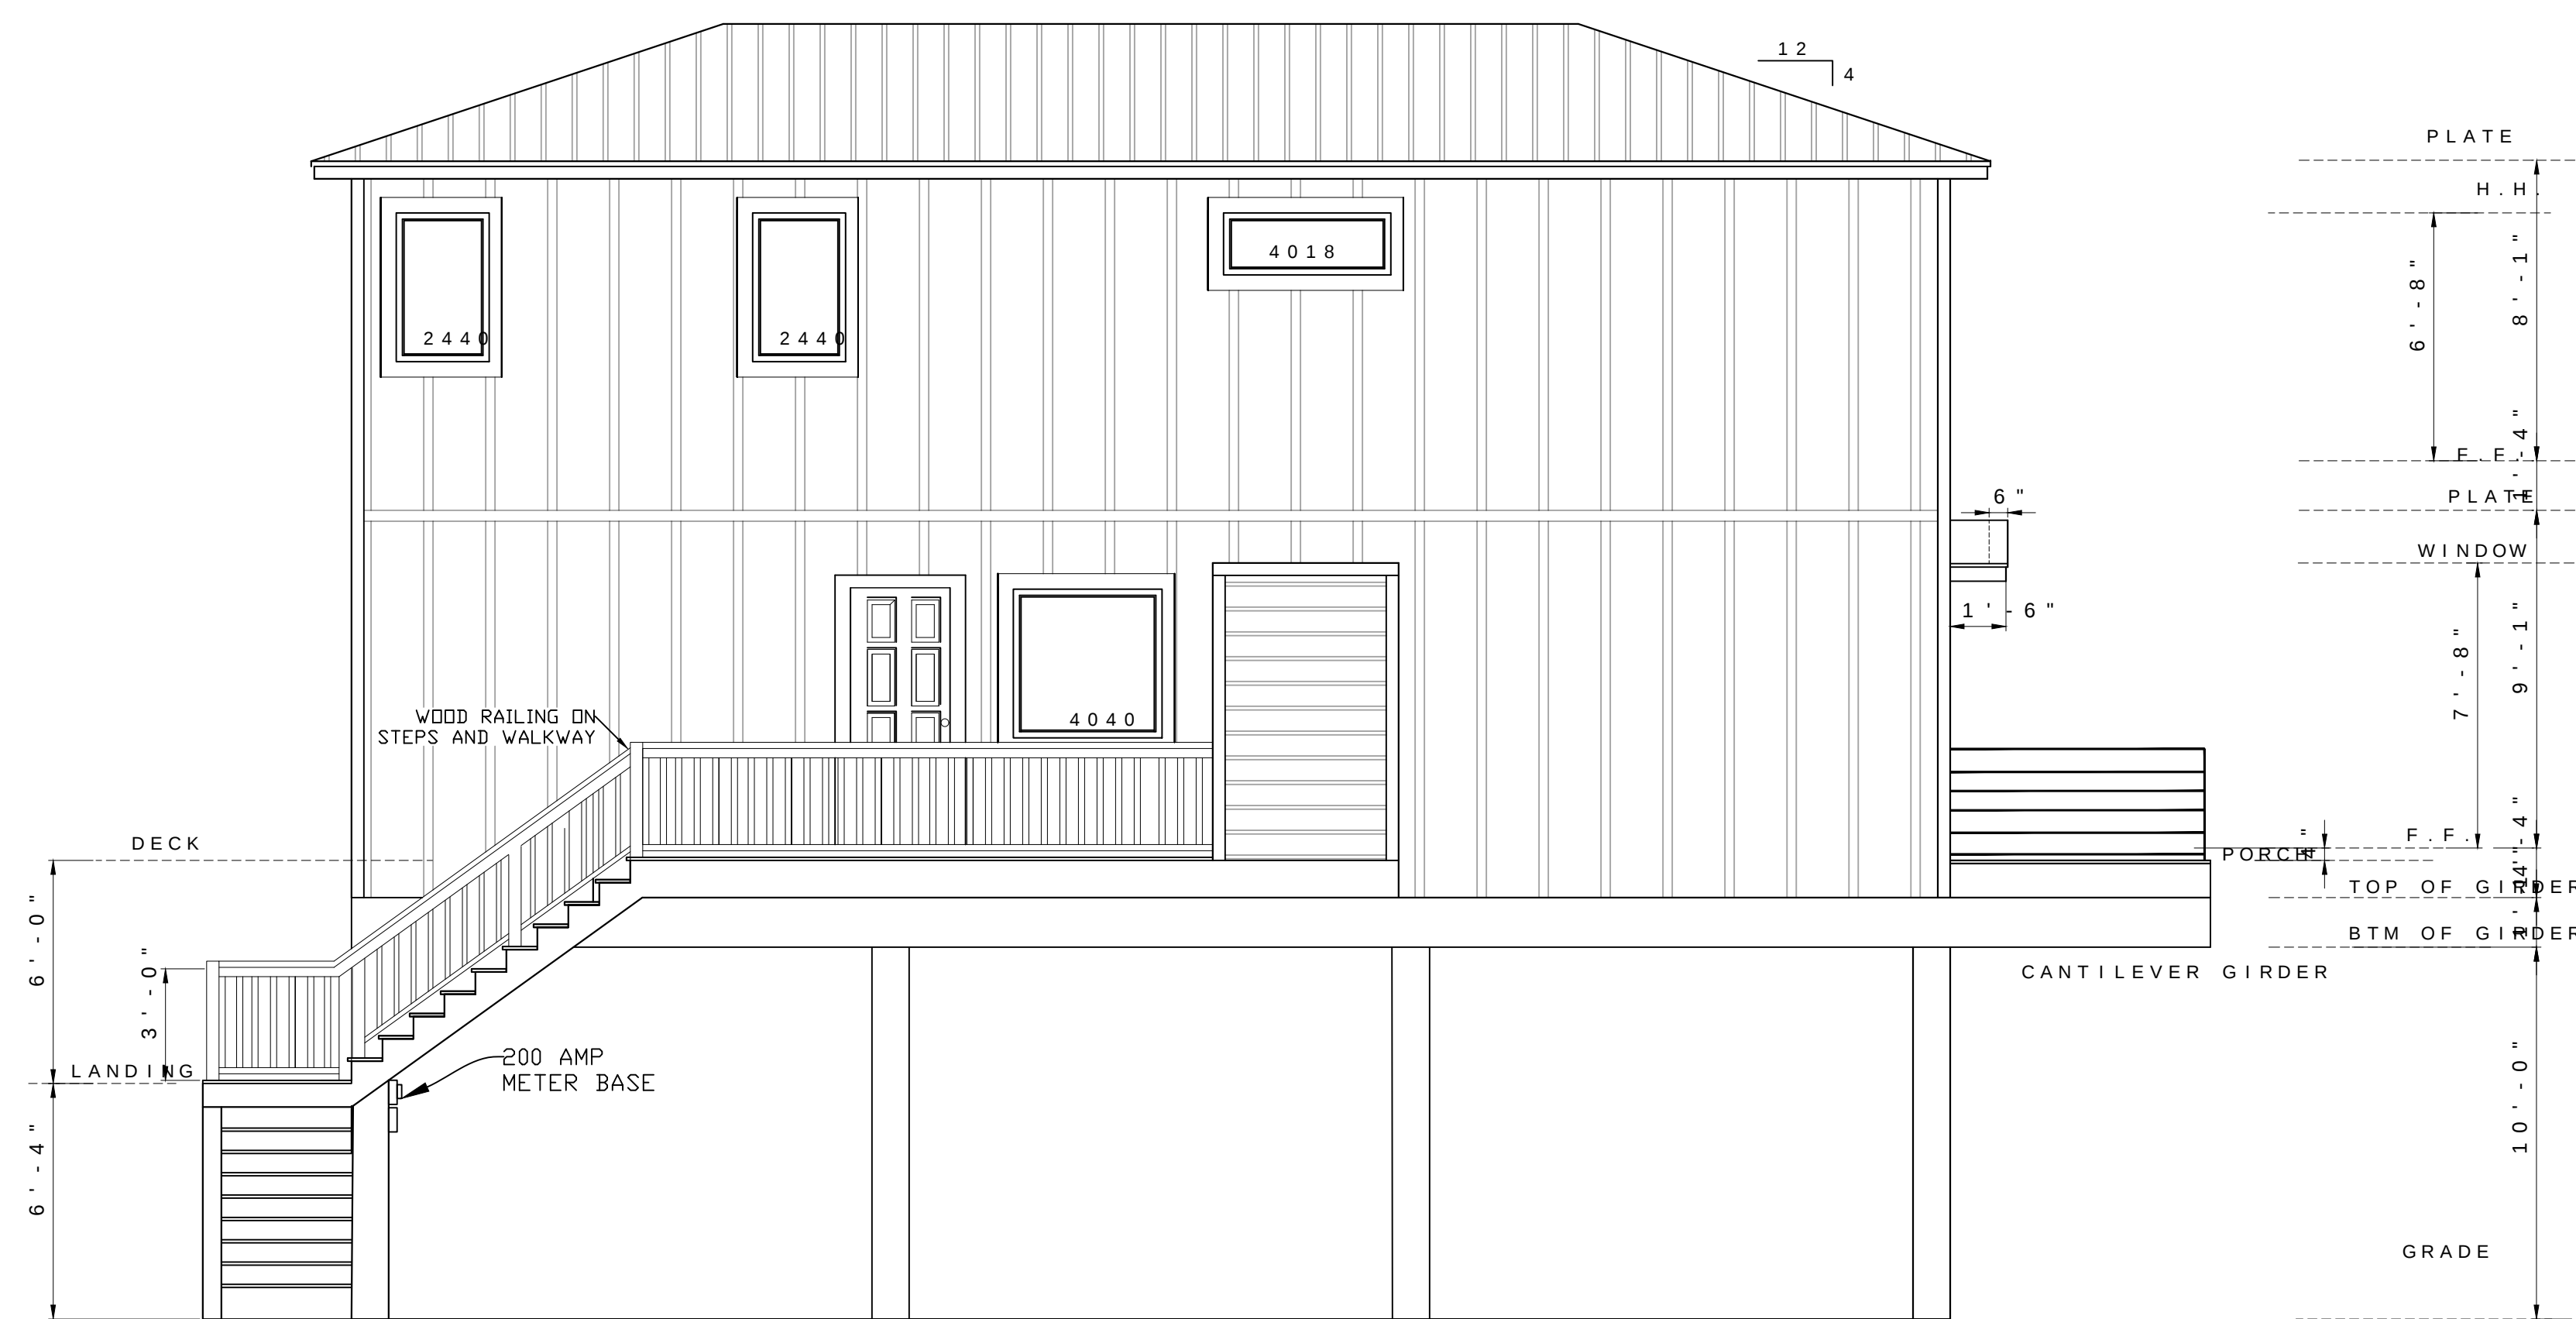

FRONT ELEVATION

SCALE: 1/4" = 1'-0"



LEFT SIDE ELEVATION

SCALE: 1/4" = 1'-0"

DESCRIPTION





LUCY MODEL


DRAWN BY: W. RICHARDSON

DATE: 11-18-2021

SHEET:

1
OF 7

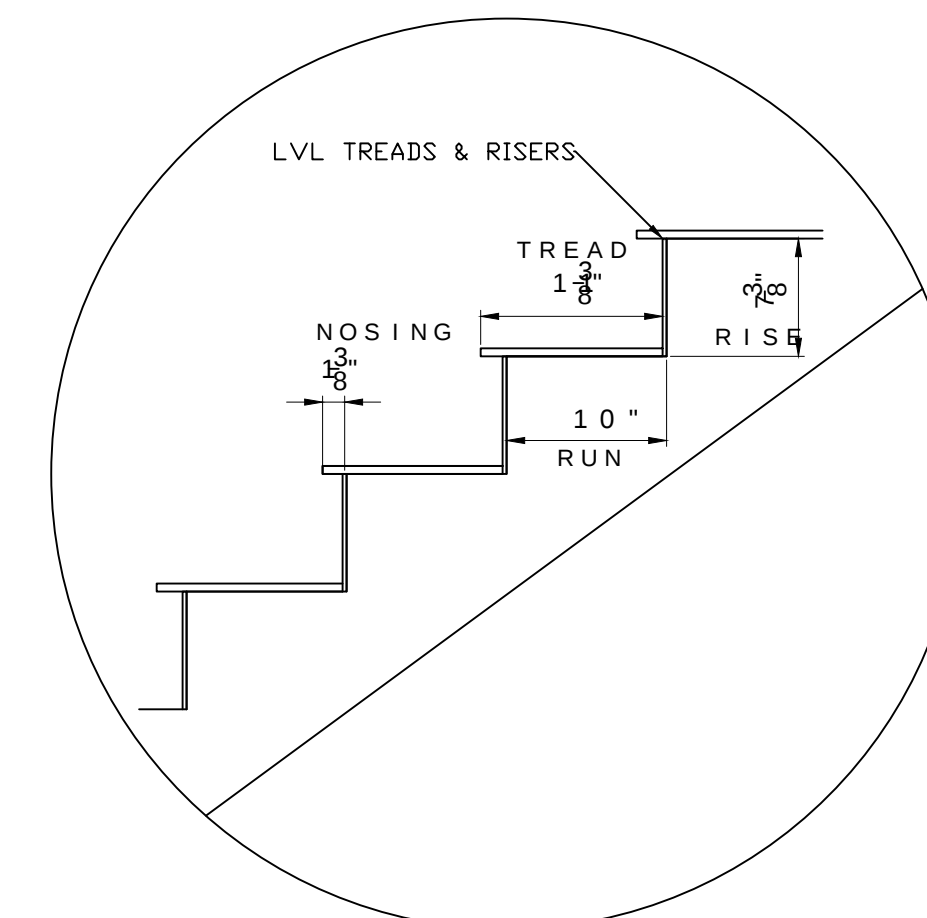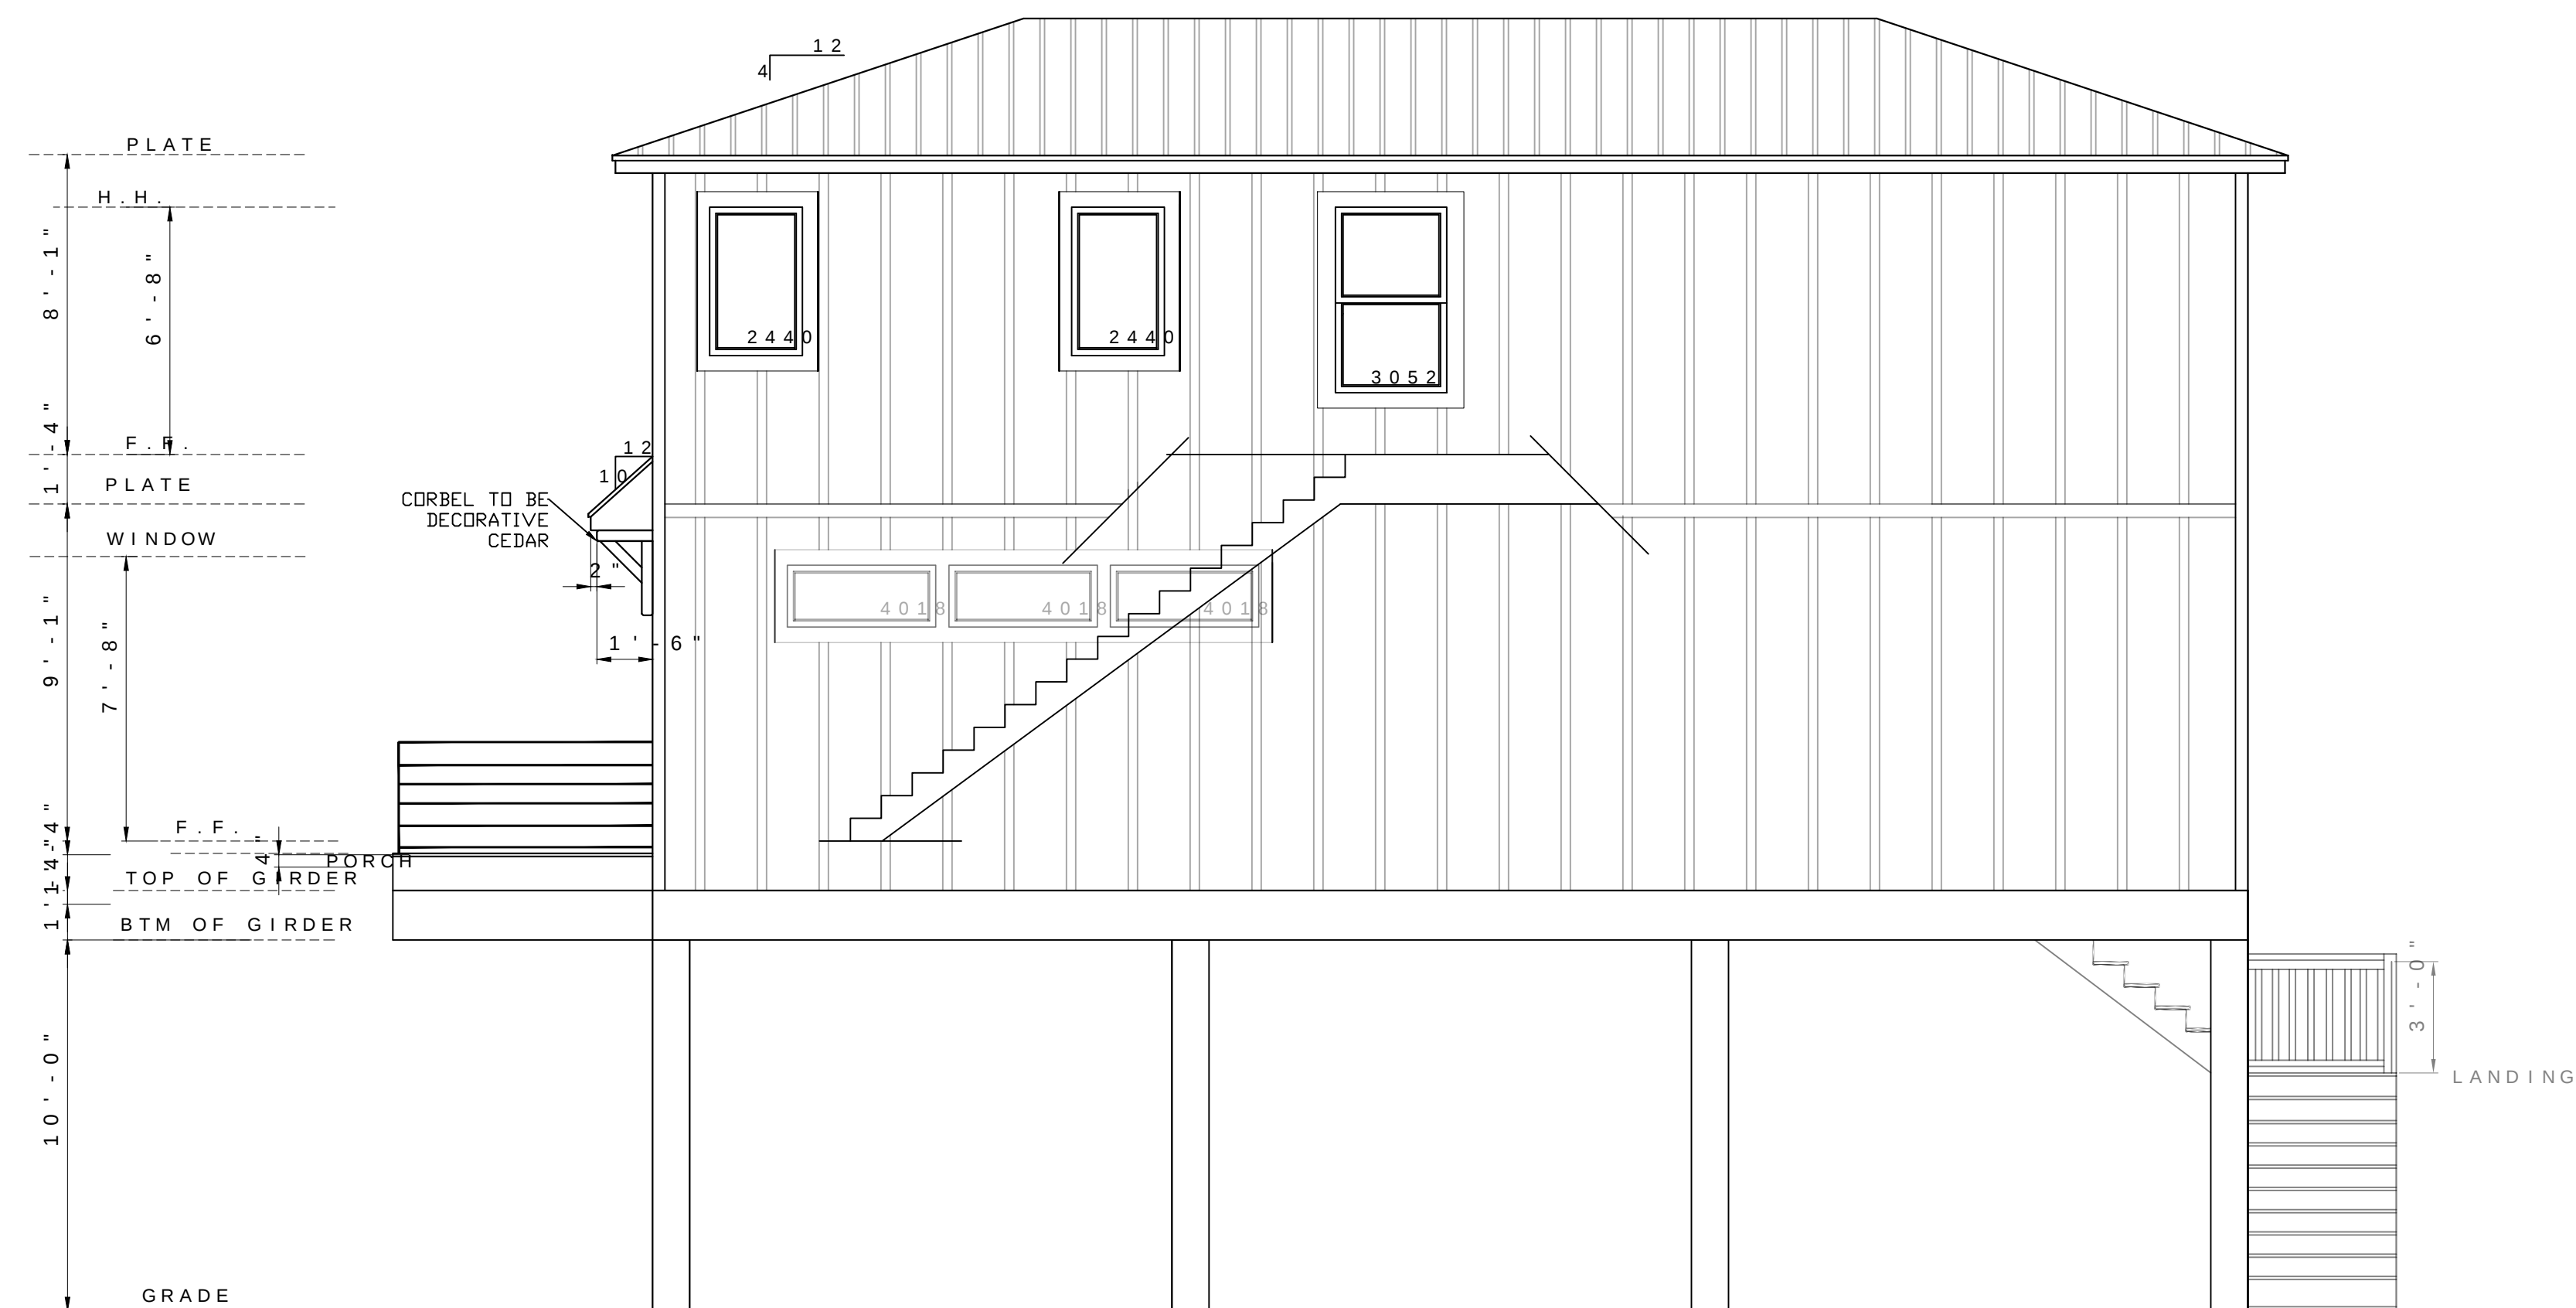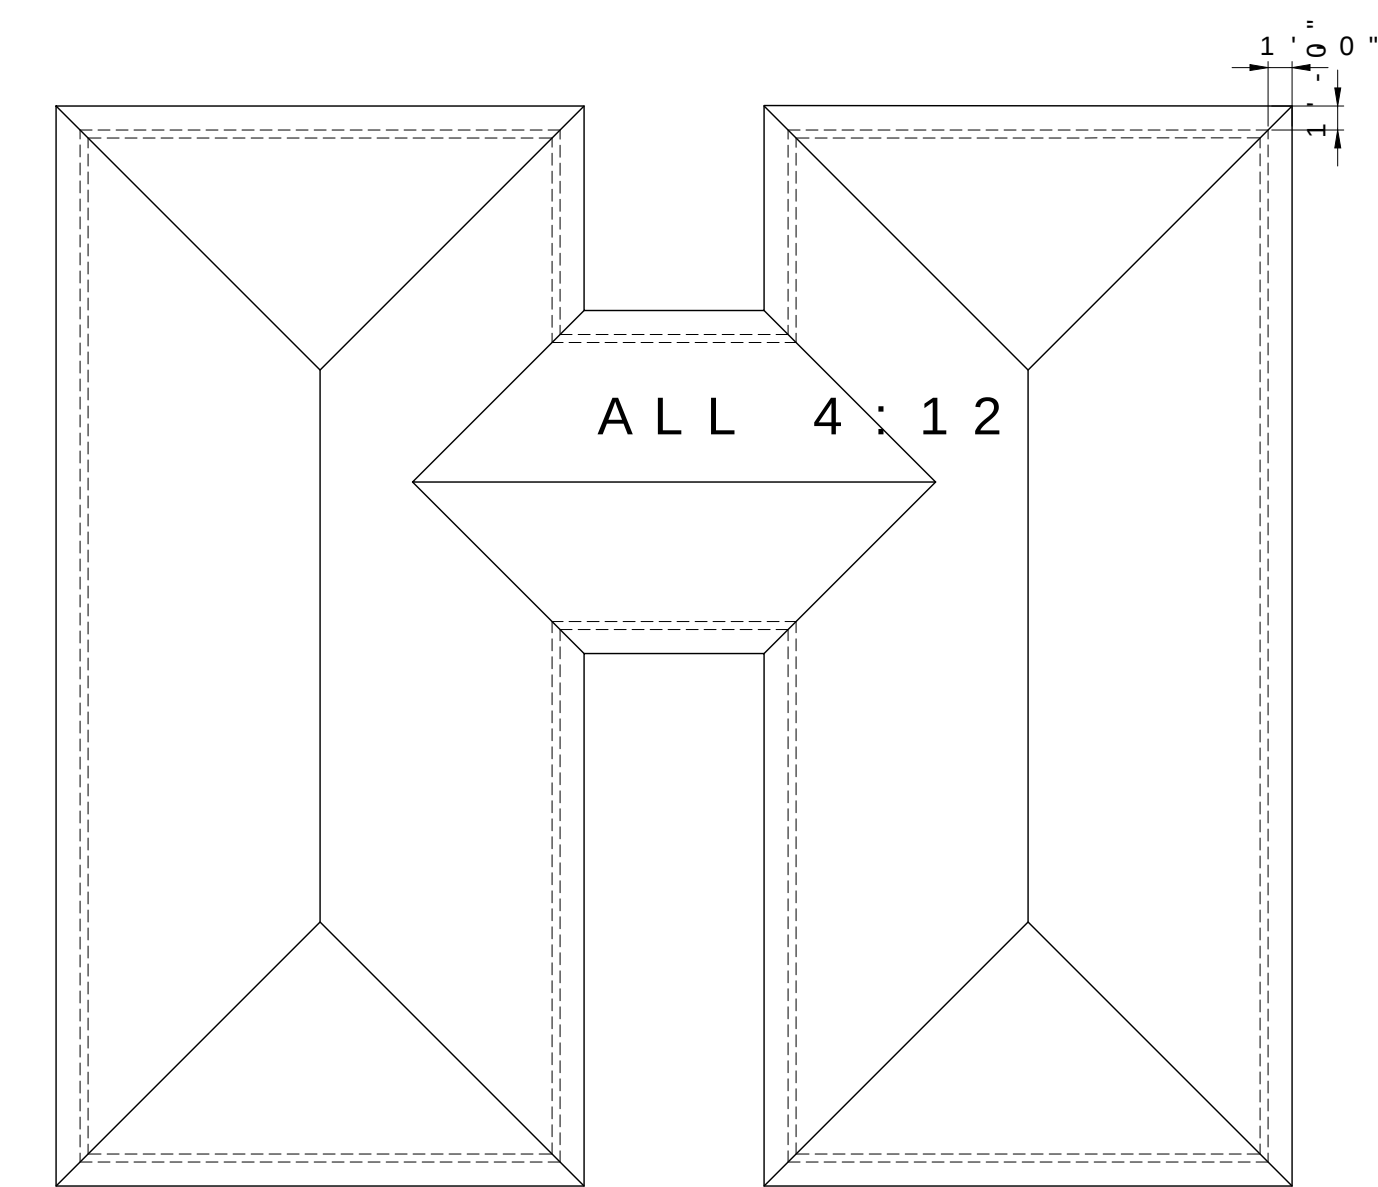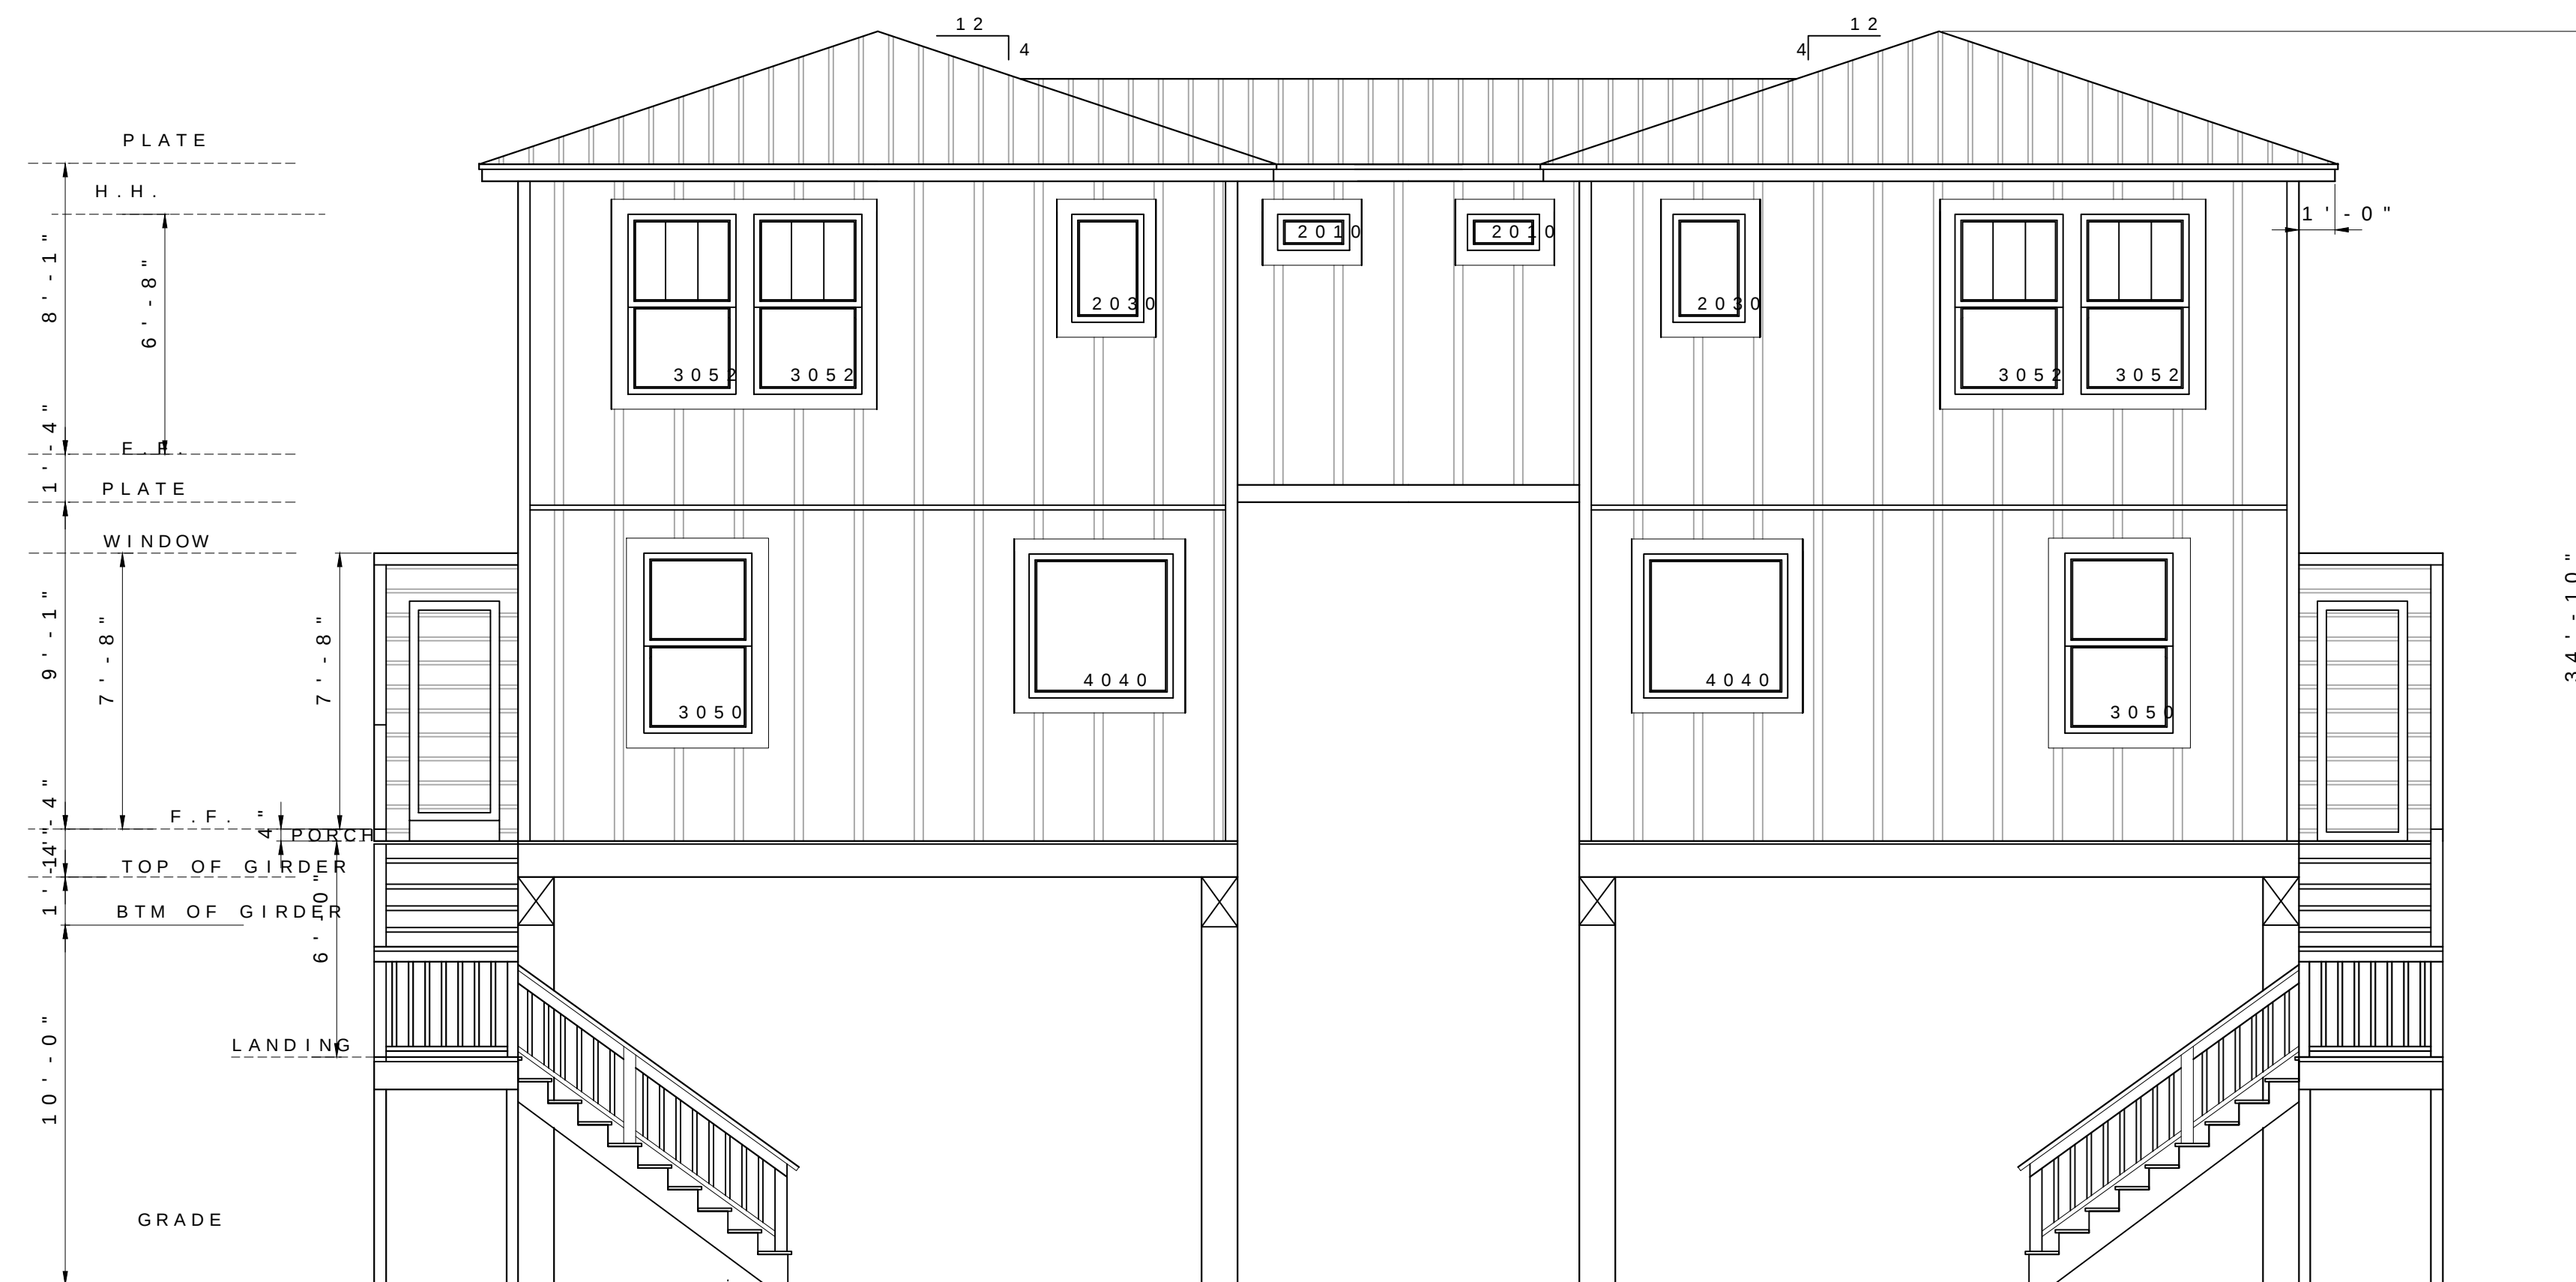


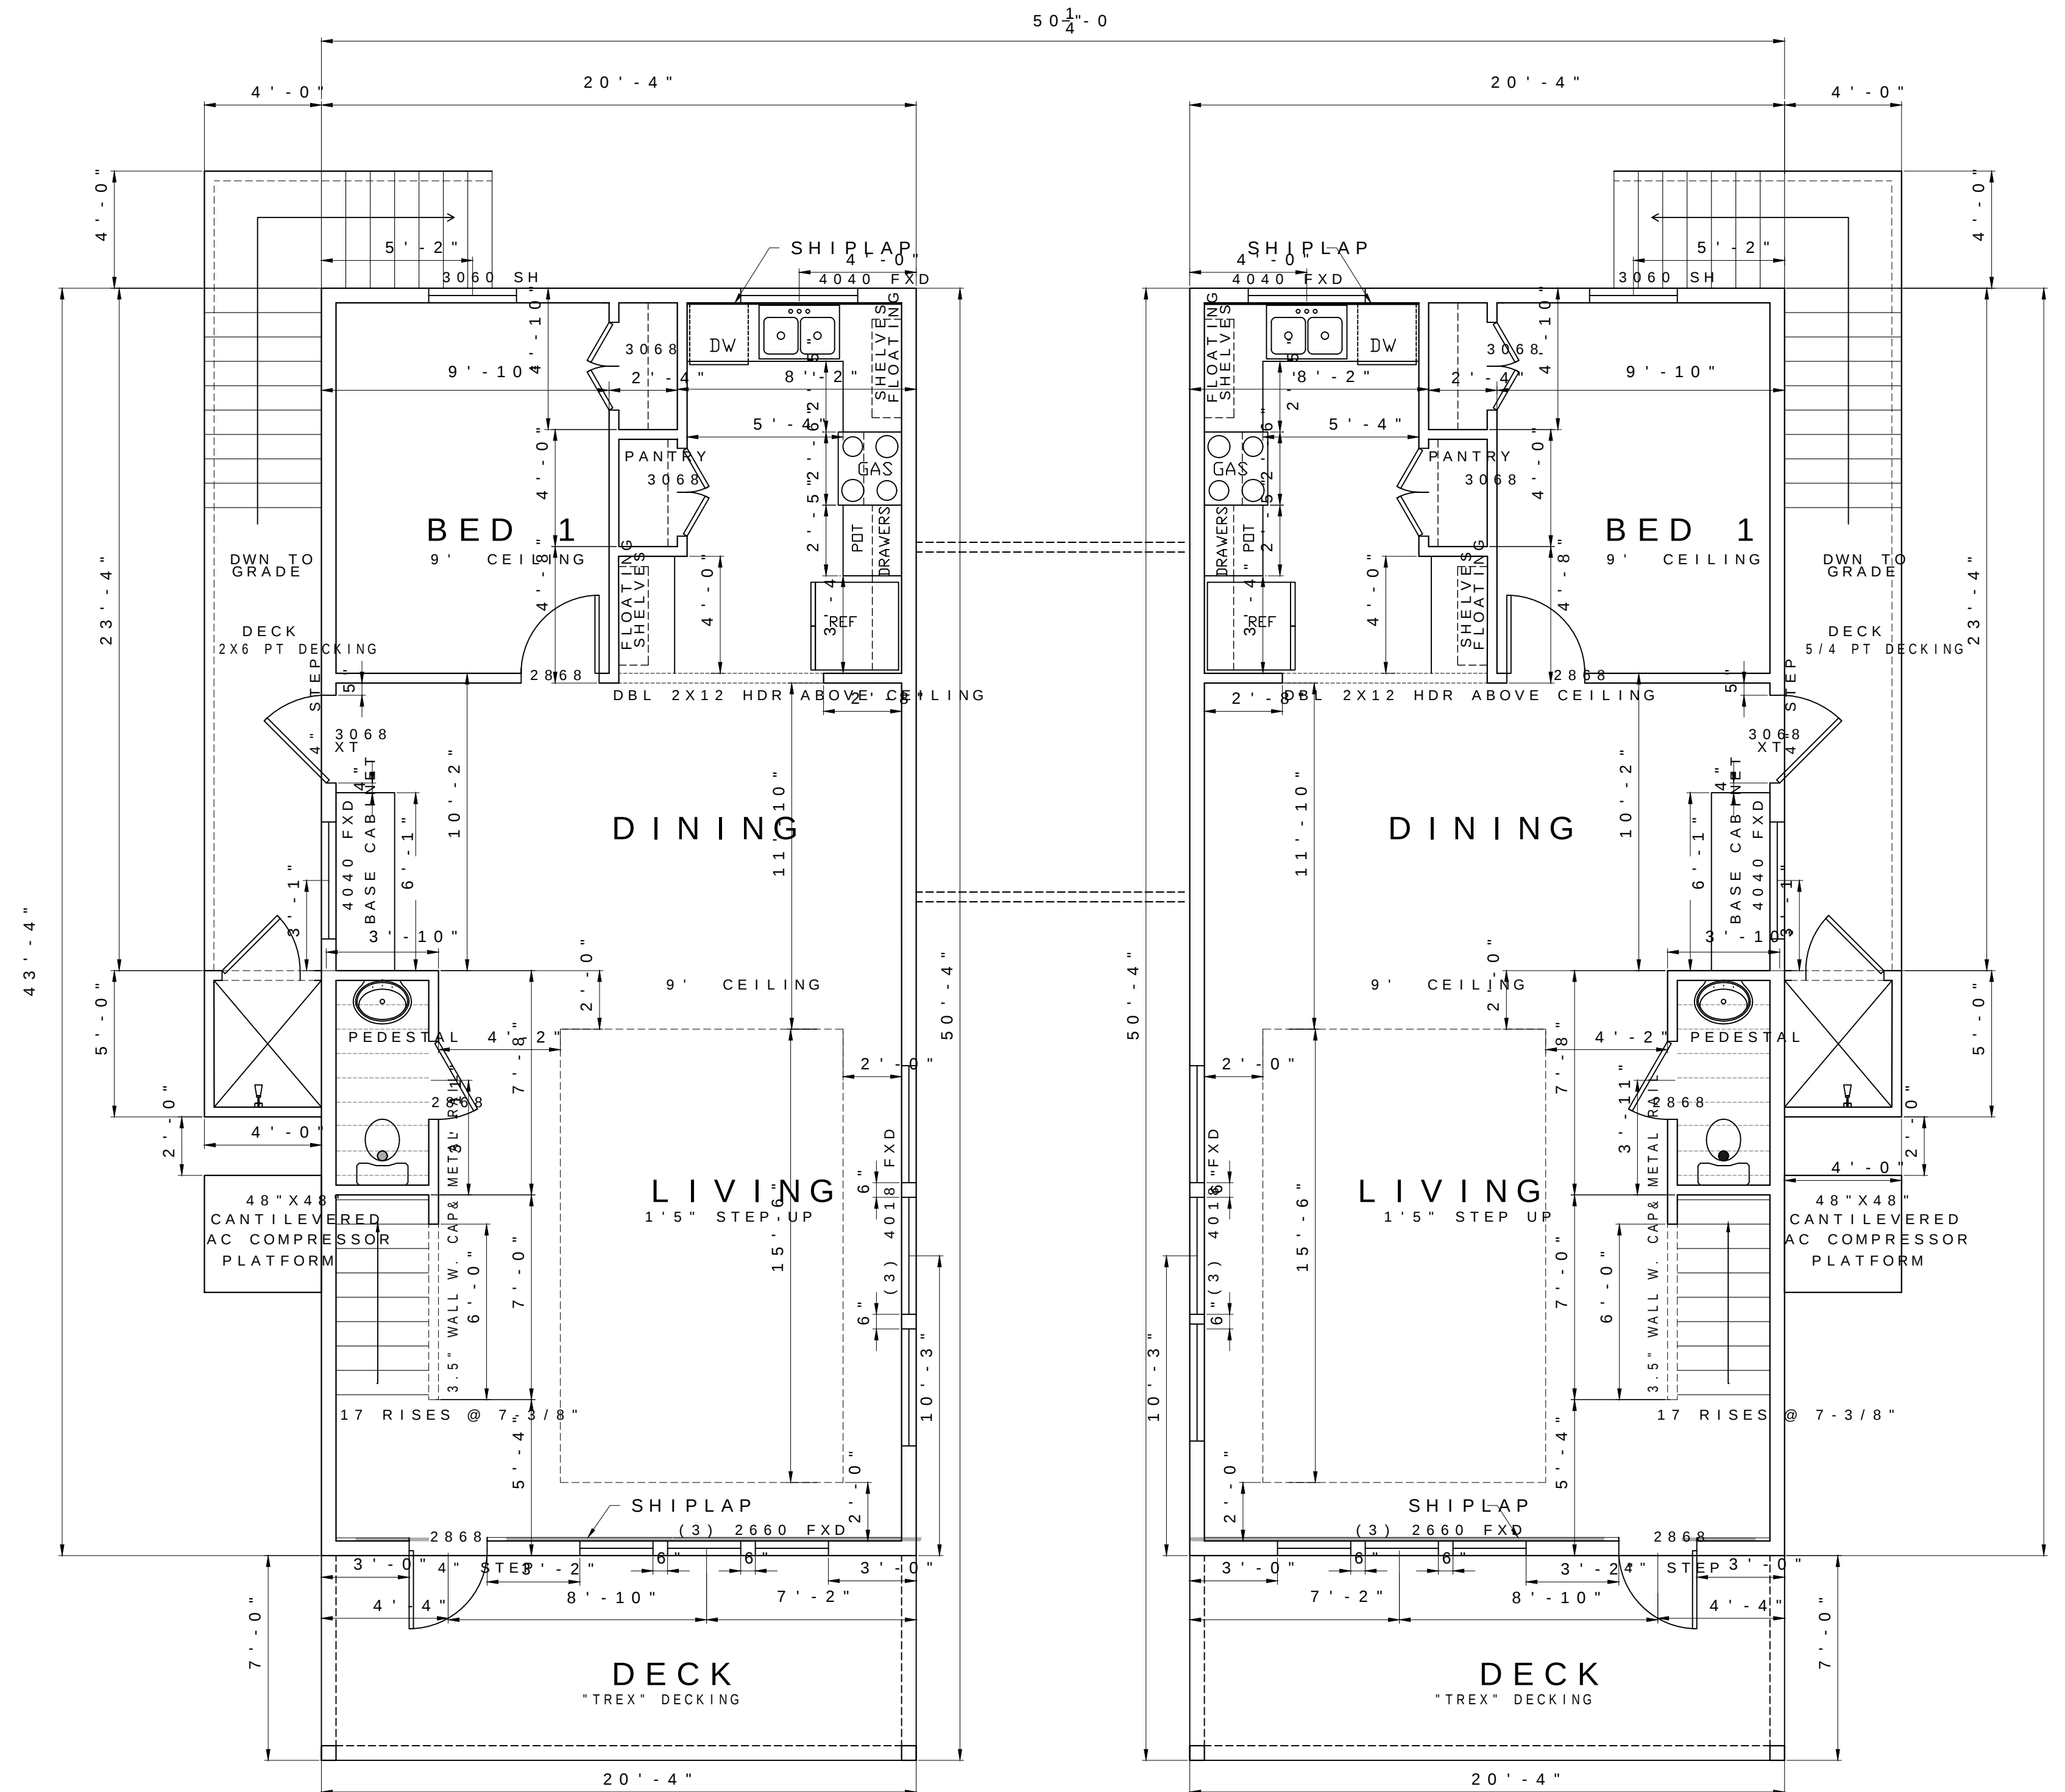


LOWER FLOORPLAN
SCALE: 1/4"=1'-0"

NOTE:
ALL EXTERIOR WALLS 2X6


SQFT. BREAKDOWN 11-18-2021	
HEATED DWN881SF HEATED UP:897SF HEATED: 1778SF	
LIVING ROOM: 23SF DINING: 189SF KITCHEN: 112SF BEDROOM 1:128SF HALF BATH: 22SF	
BEDROOM 2:159SF BATH 2: 60SF LAUNDRY: 11SF HALL: 90SF WIC: 33SF AC CLOSET 14SF BEDROOM 3:128SF BATH 3: 63SF BEDROOM 4:186SF BATH 4: 51SF	
LUCY MODEL	
DESCRIPTION	
DRAWN BY: W. RICHARDSON	
DATE: 11-18-2021	
SHEET: 3 OF 7	

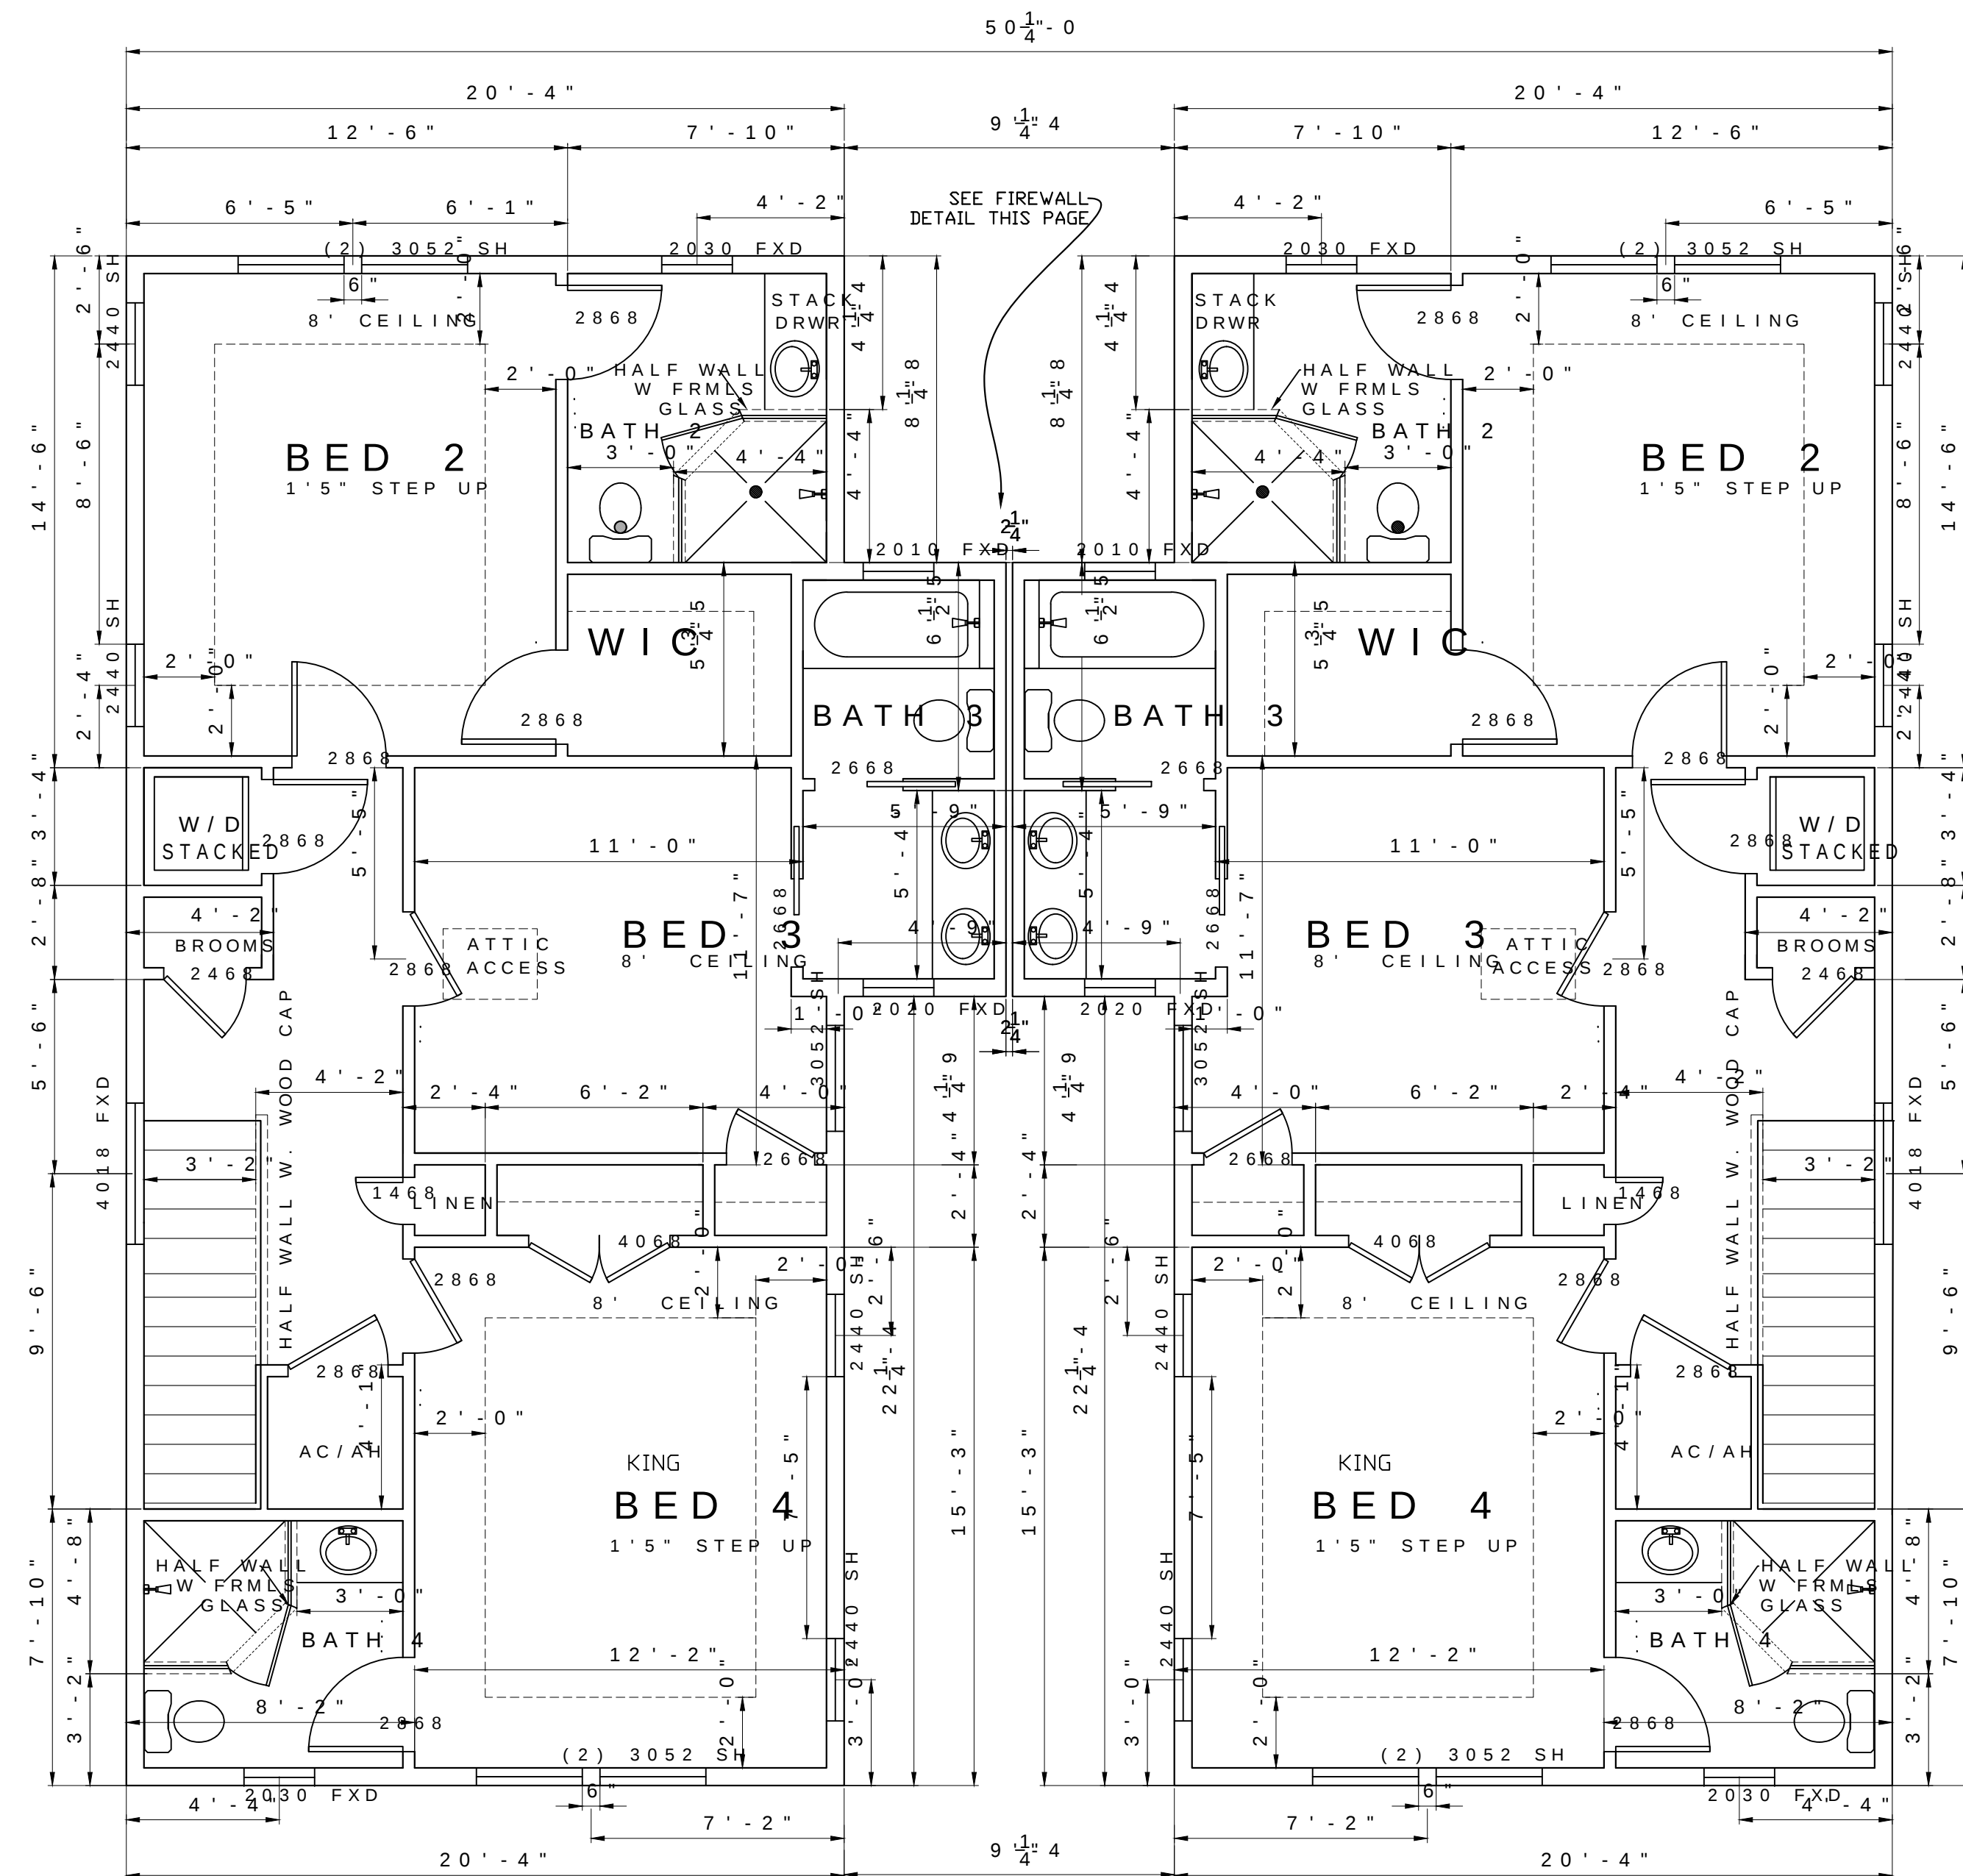


UPPER FLOORPLAN
SCALE: 1/4" = 1' - 0"

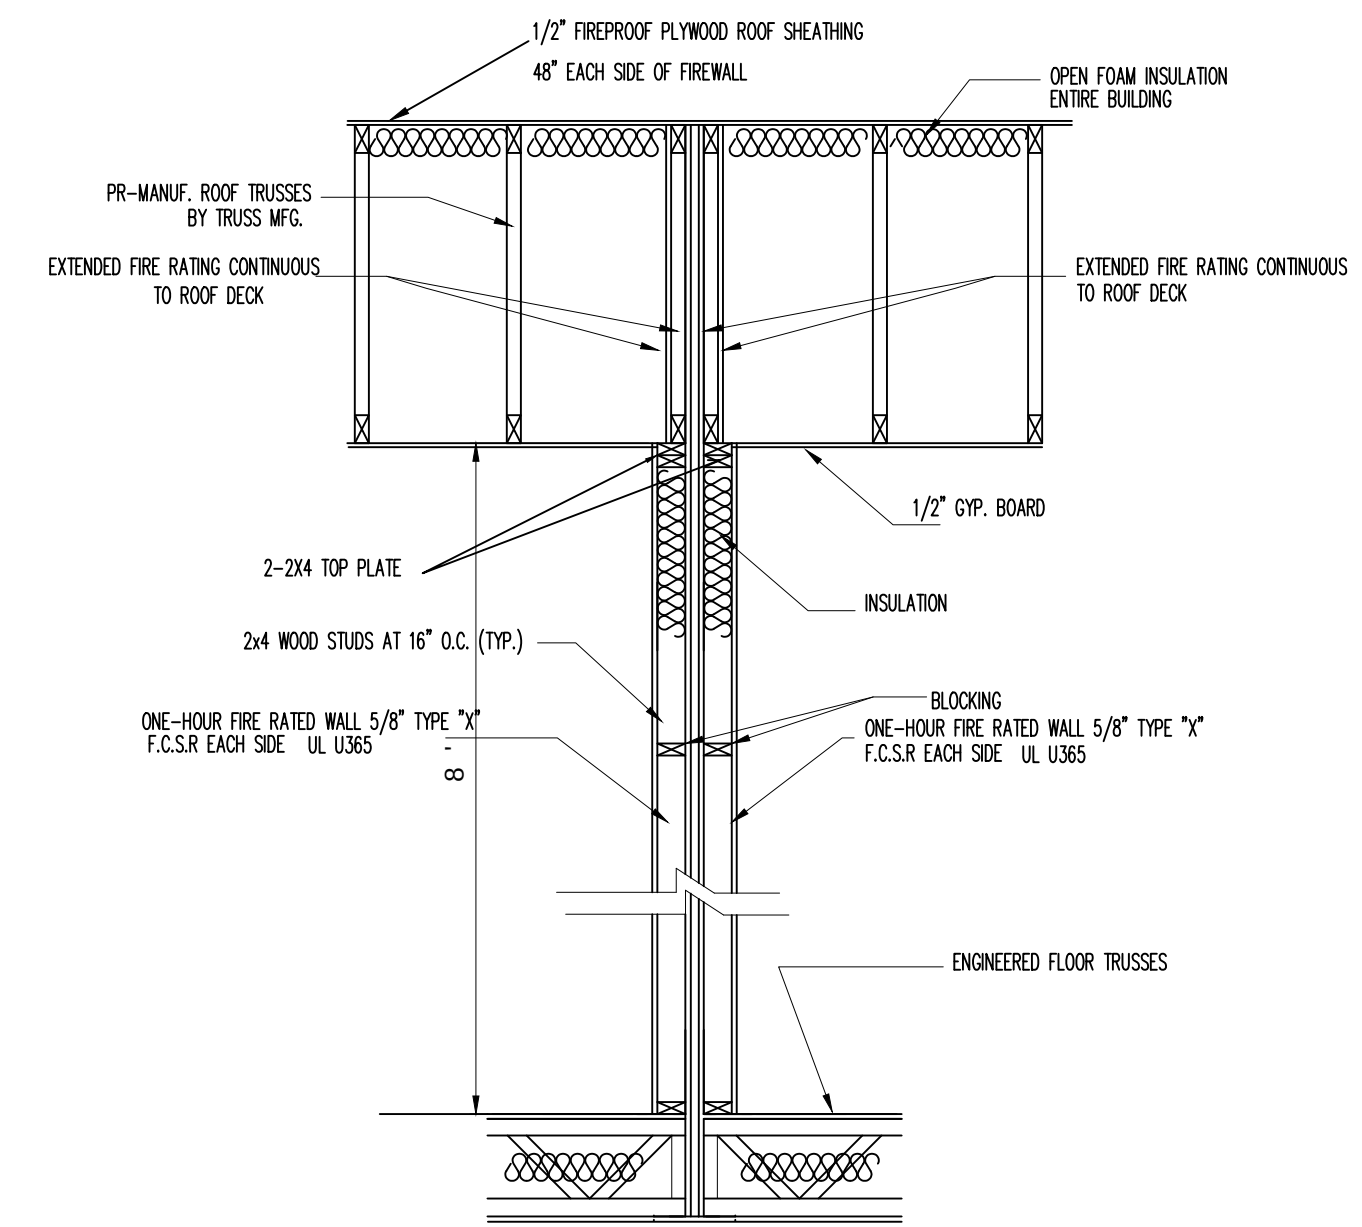

SECTION THRU UPPER LEVEL
FIRE WALL
SCALE: 1/2" = 1' - 0"
SEE ELEVATION FOR SIDING DETAIL

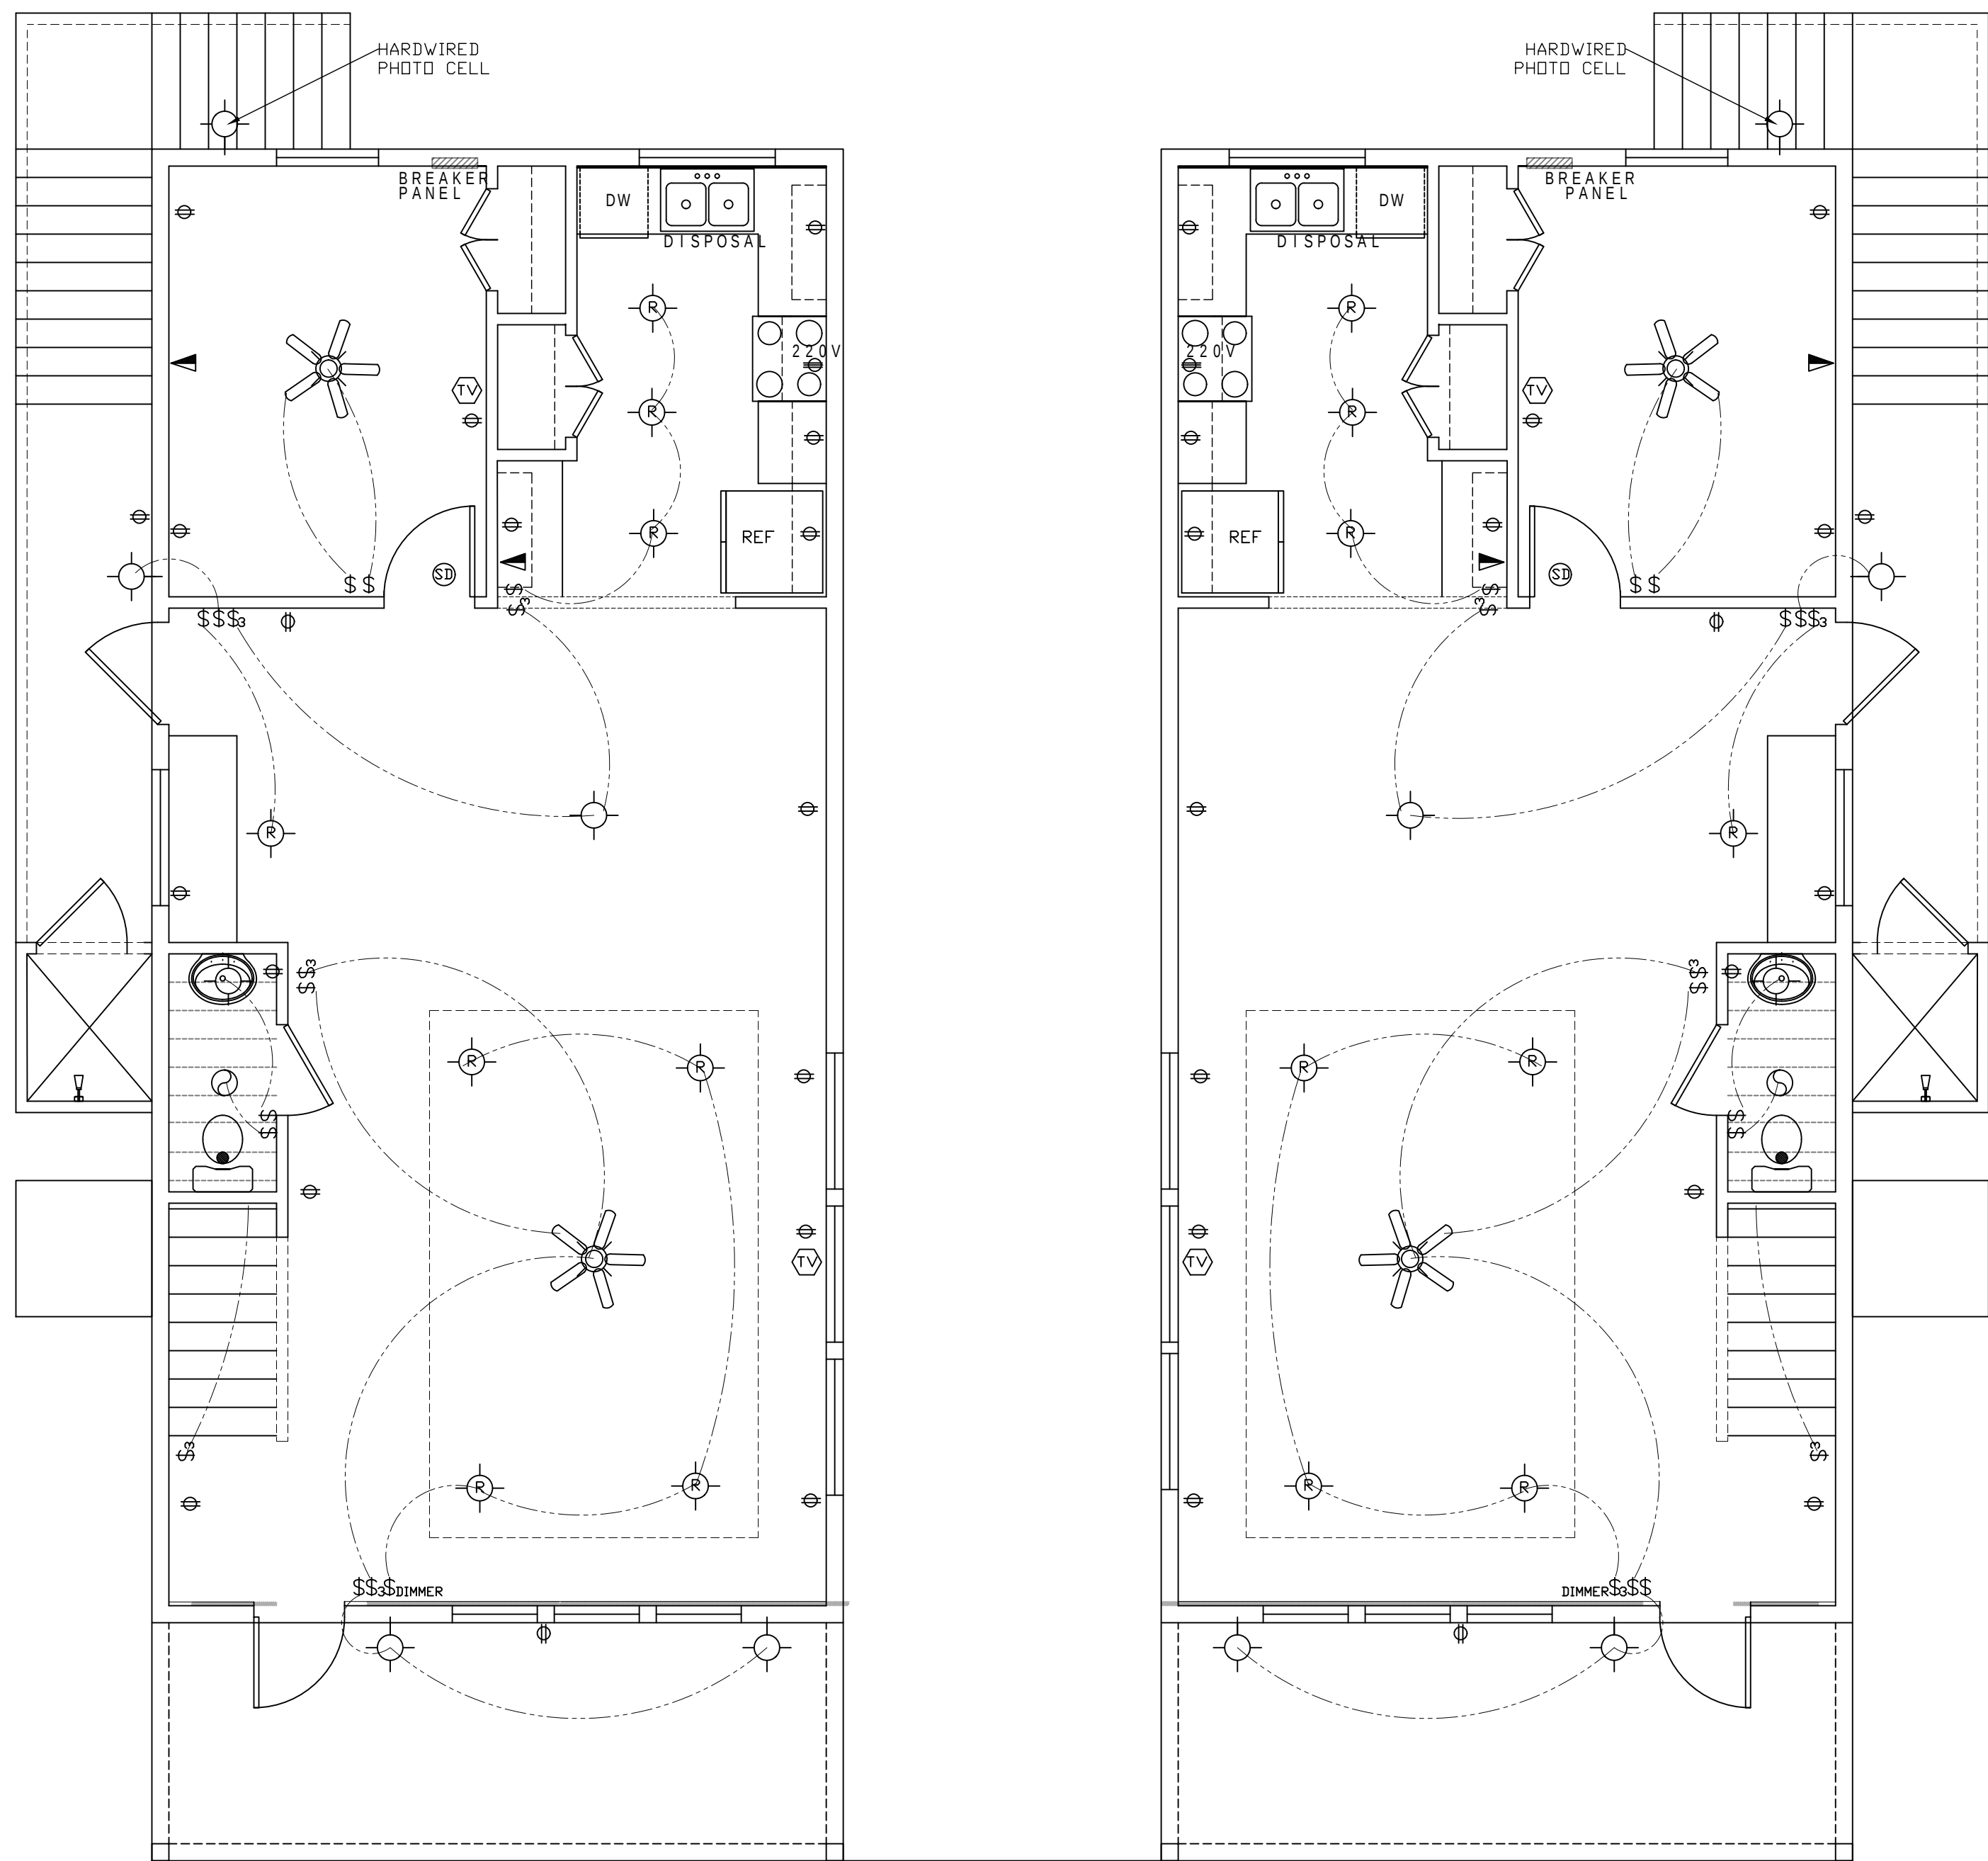

ELECTRICAL PLAN
LOWER LEVEL

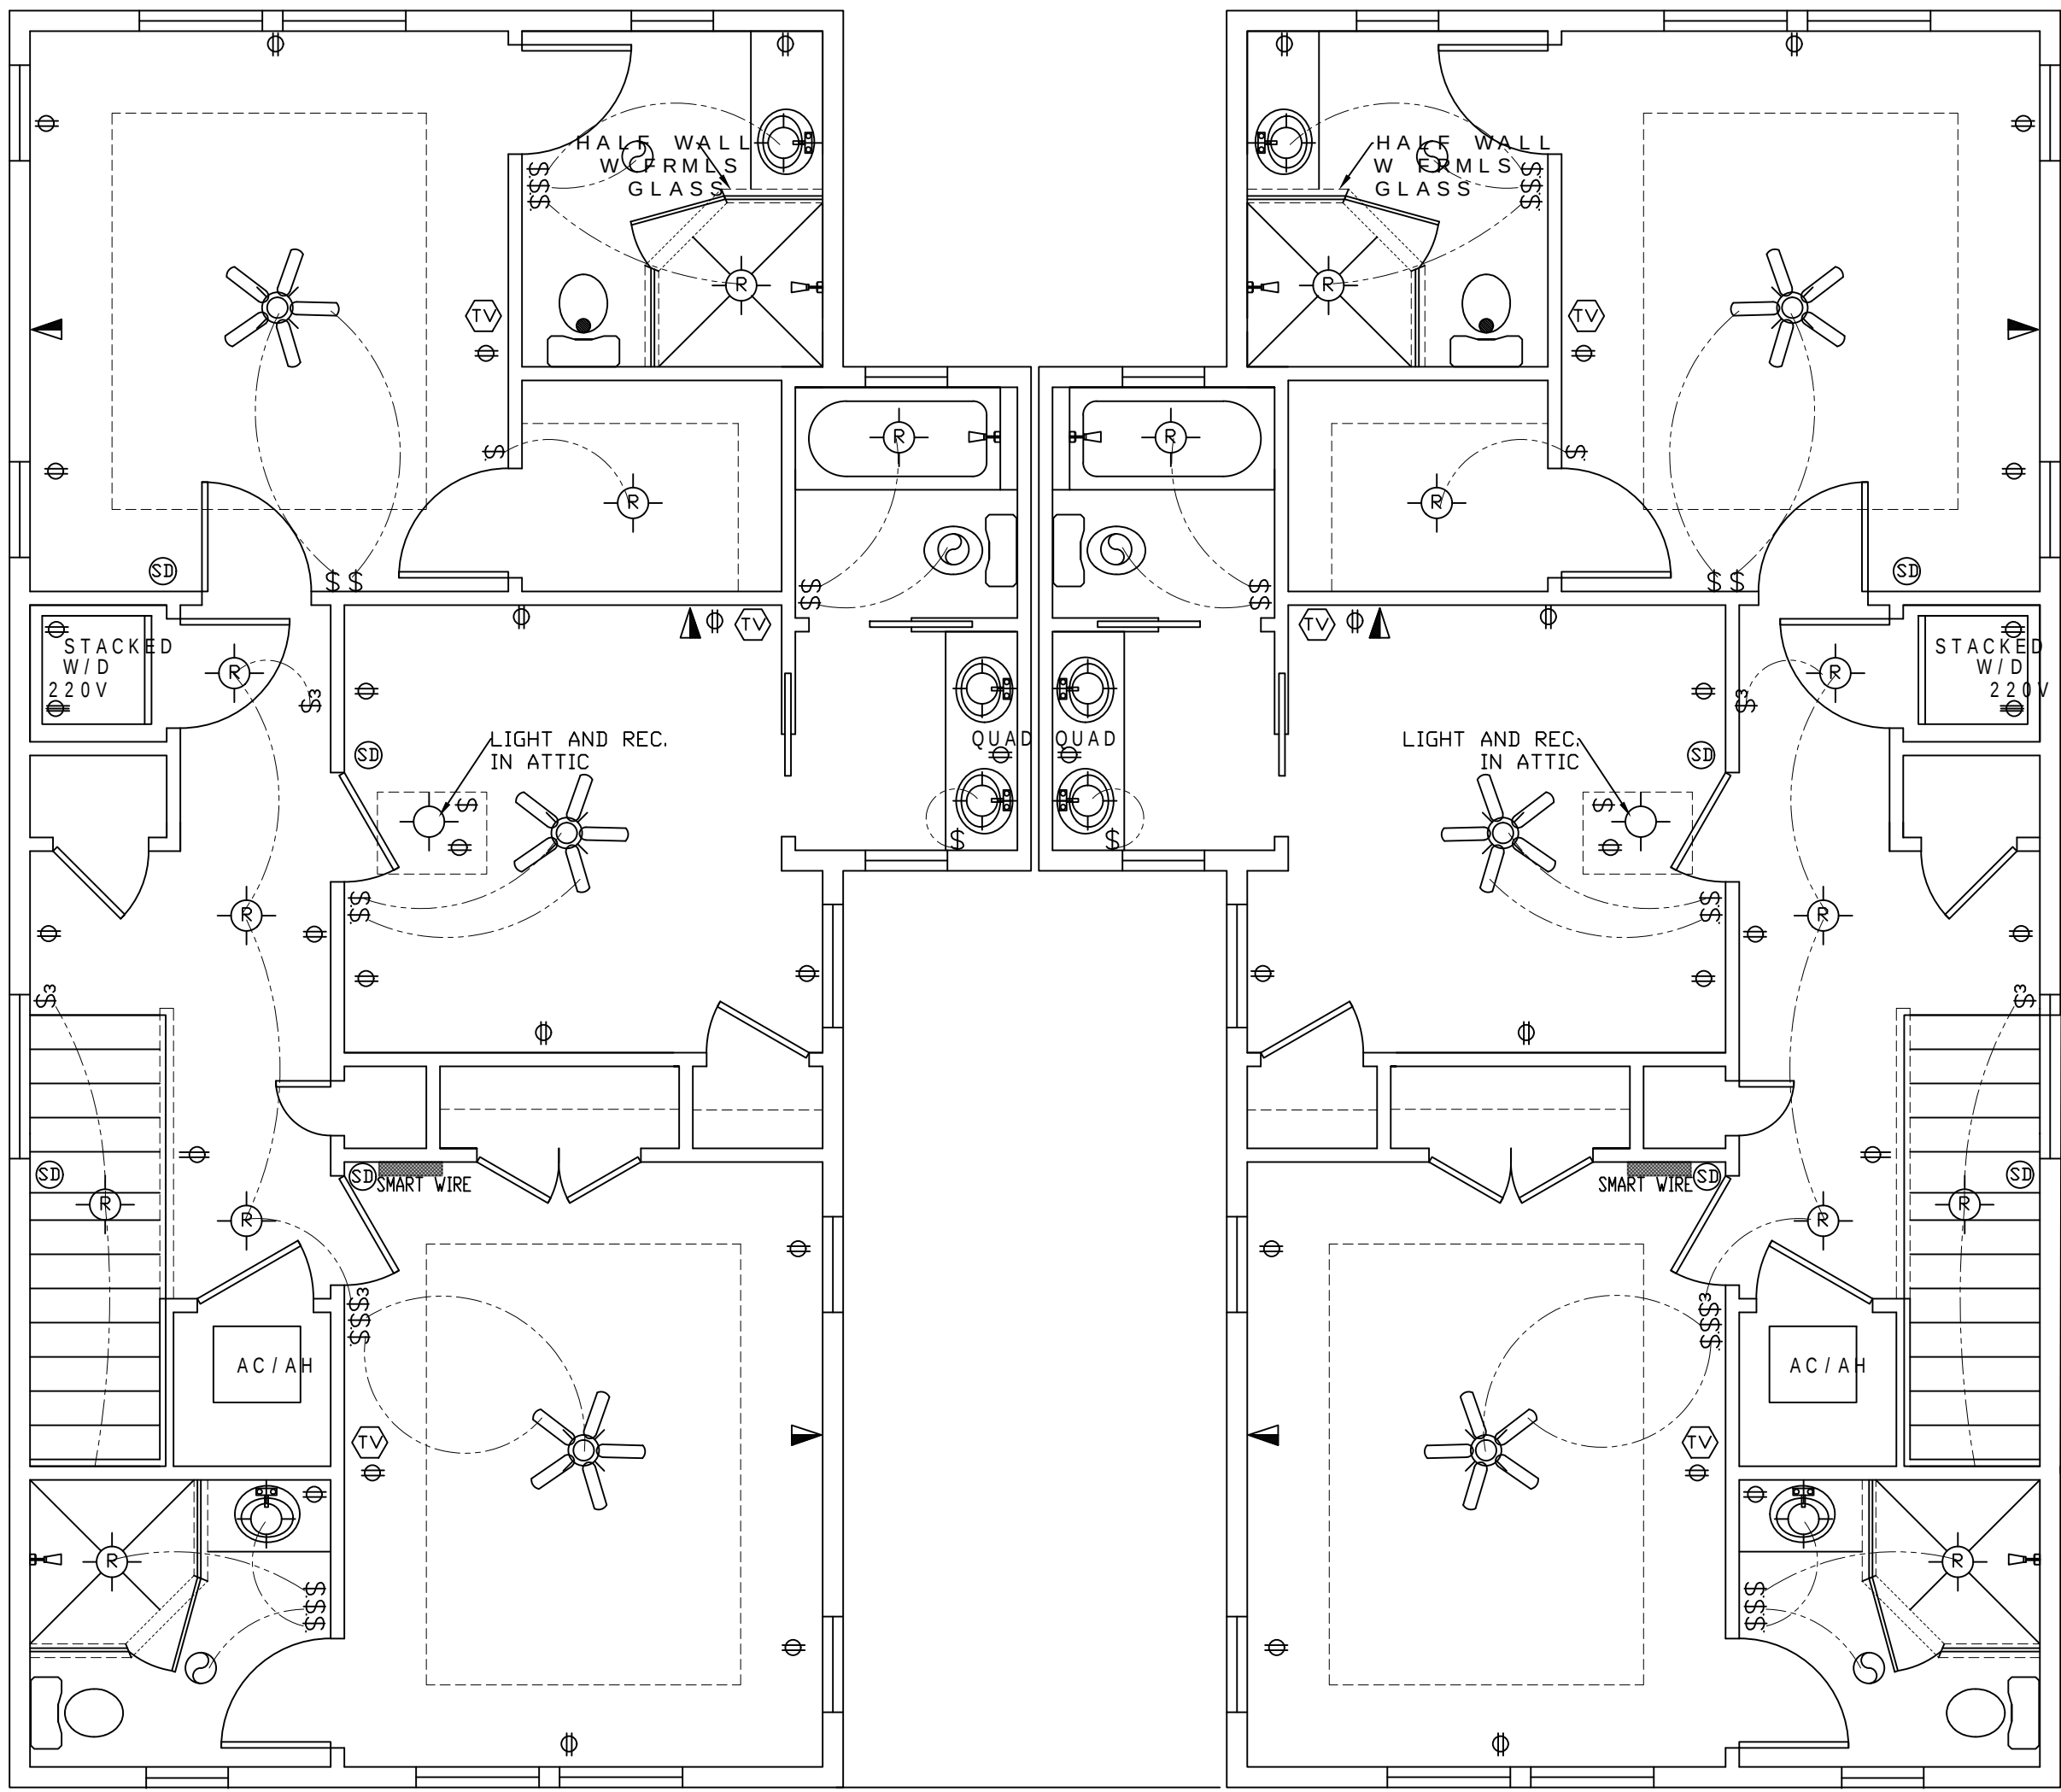

ELECTRICAL PLAN
UPPER LEVEL

ALL OUTLETS WILL BE LOCATED PER BUILDING CODE, NOT PER PLANS.

	CEILING FAN/ LIGHT COMBO
	SMOKE DETECTOR
	BATH FAN
	TELEPHONE
	CEILING MOUNTED LIGHT
	WALL MOUNTED LIGHT
	CABLE CONNECTION
	RECESSED LIGHT
	PENDANT LIGHT
	RECESSED EYEBALL LIGHT
	FLUORESCENT
	ROPE LIGHTING
	FLOOD LIGHT
	SINGLE POLE SWITCH
	3-WAY SWITCH
	RECEPTACLE
	DOOR BELL
	HEAT LAMP

DESCRIPTION

LUCY MODEL


DRAWN BY: W. RICHARDSON

DATE: 11-18-2021



SHEET:

5


OF 7

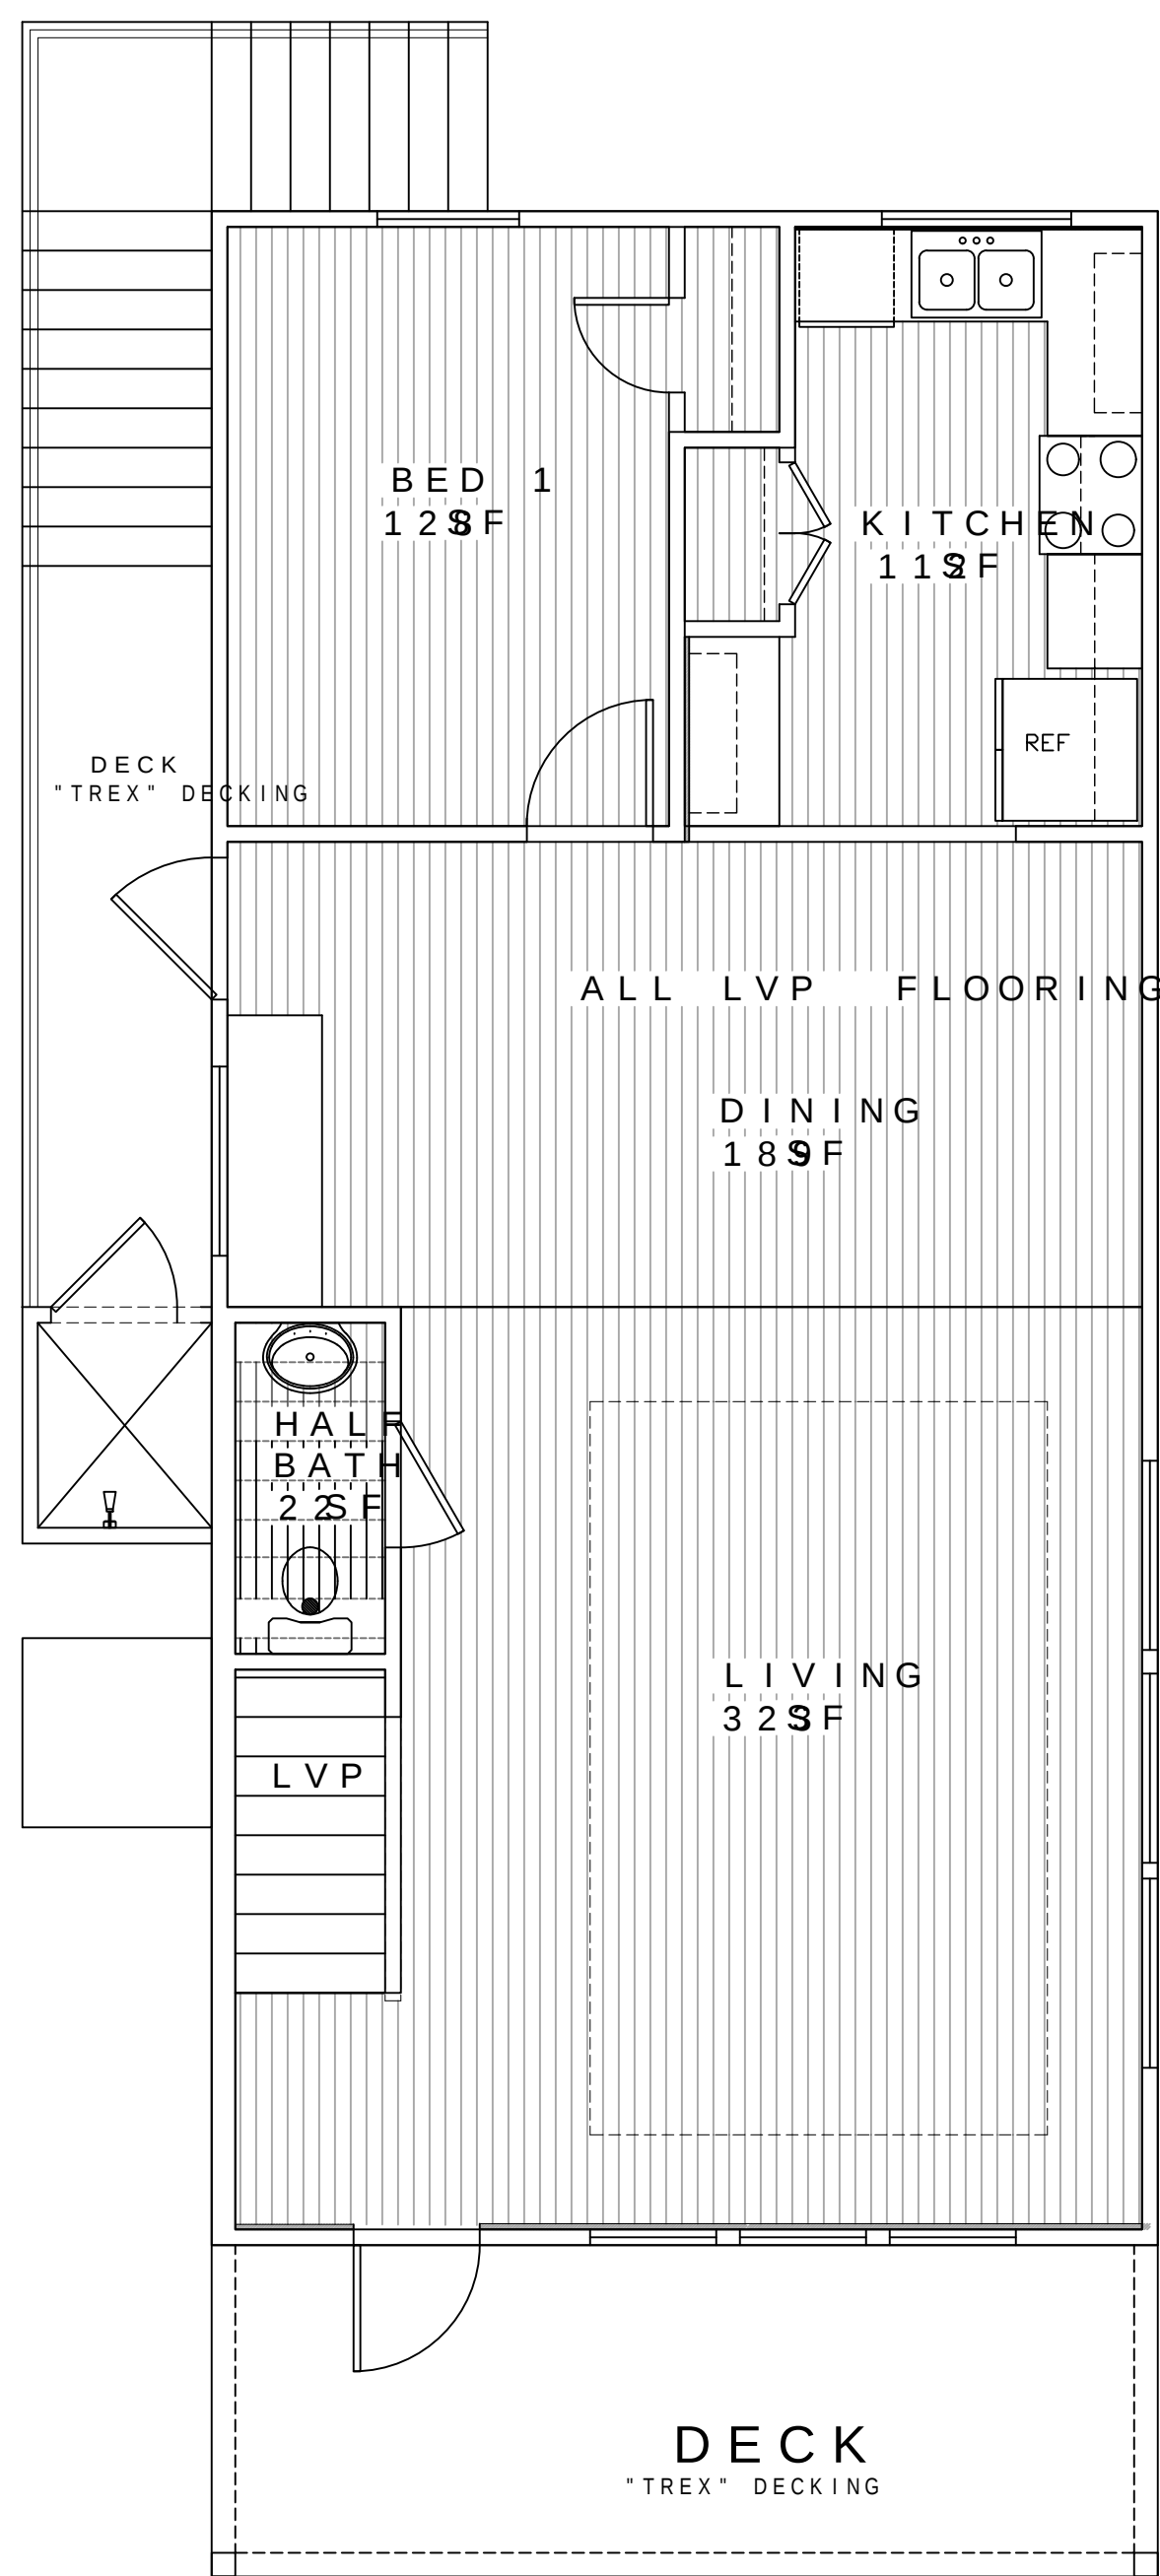


FLOORING PLAN
LOWER LEVEL

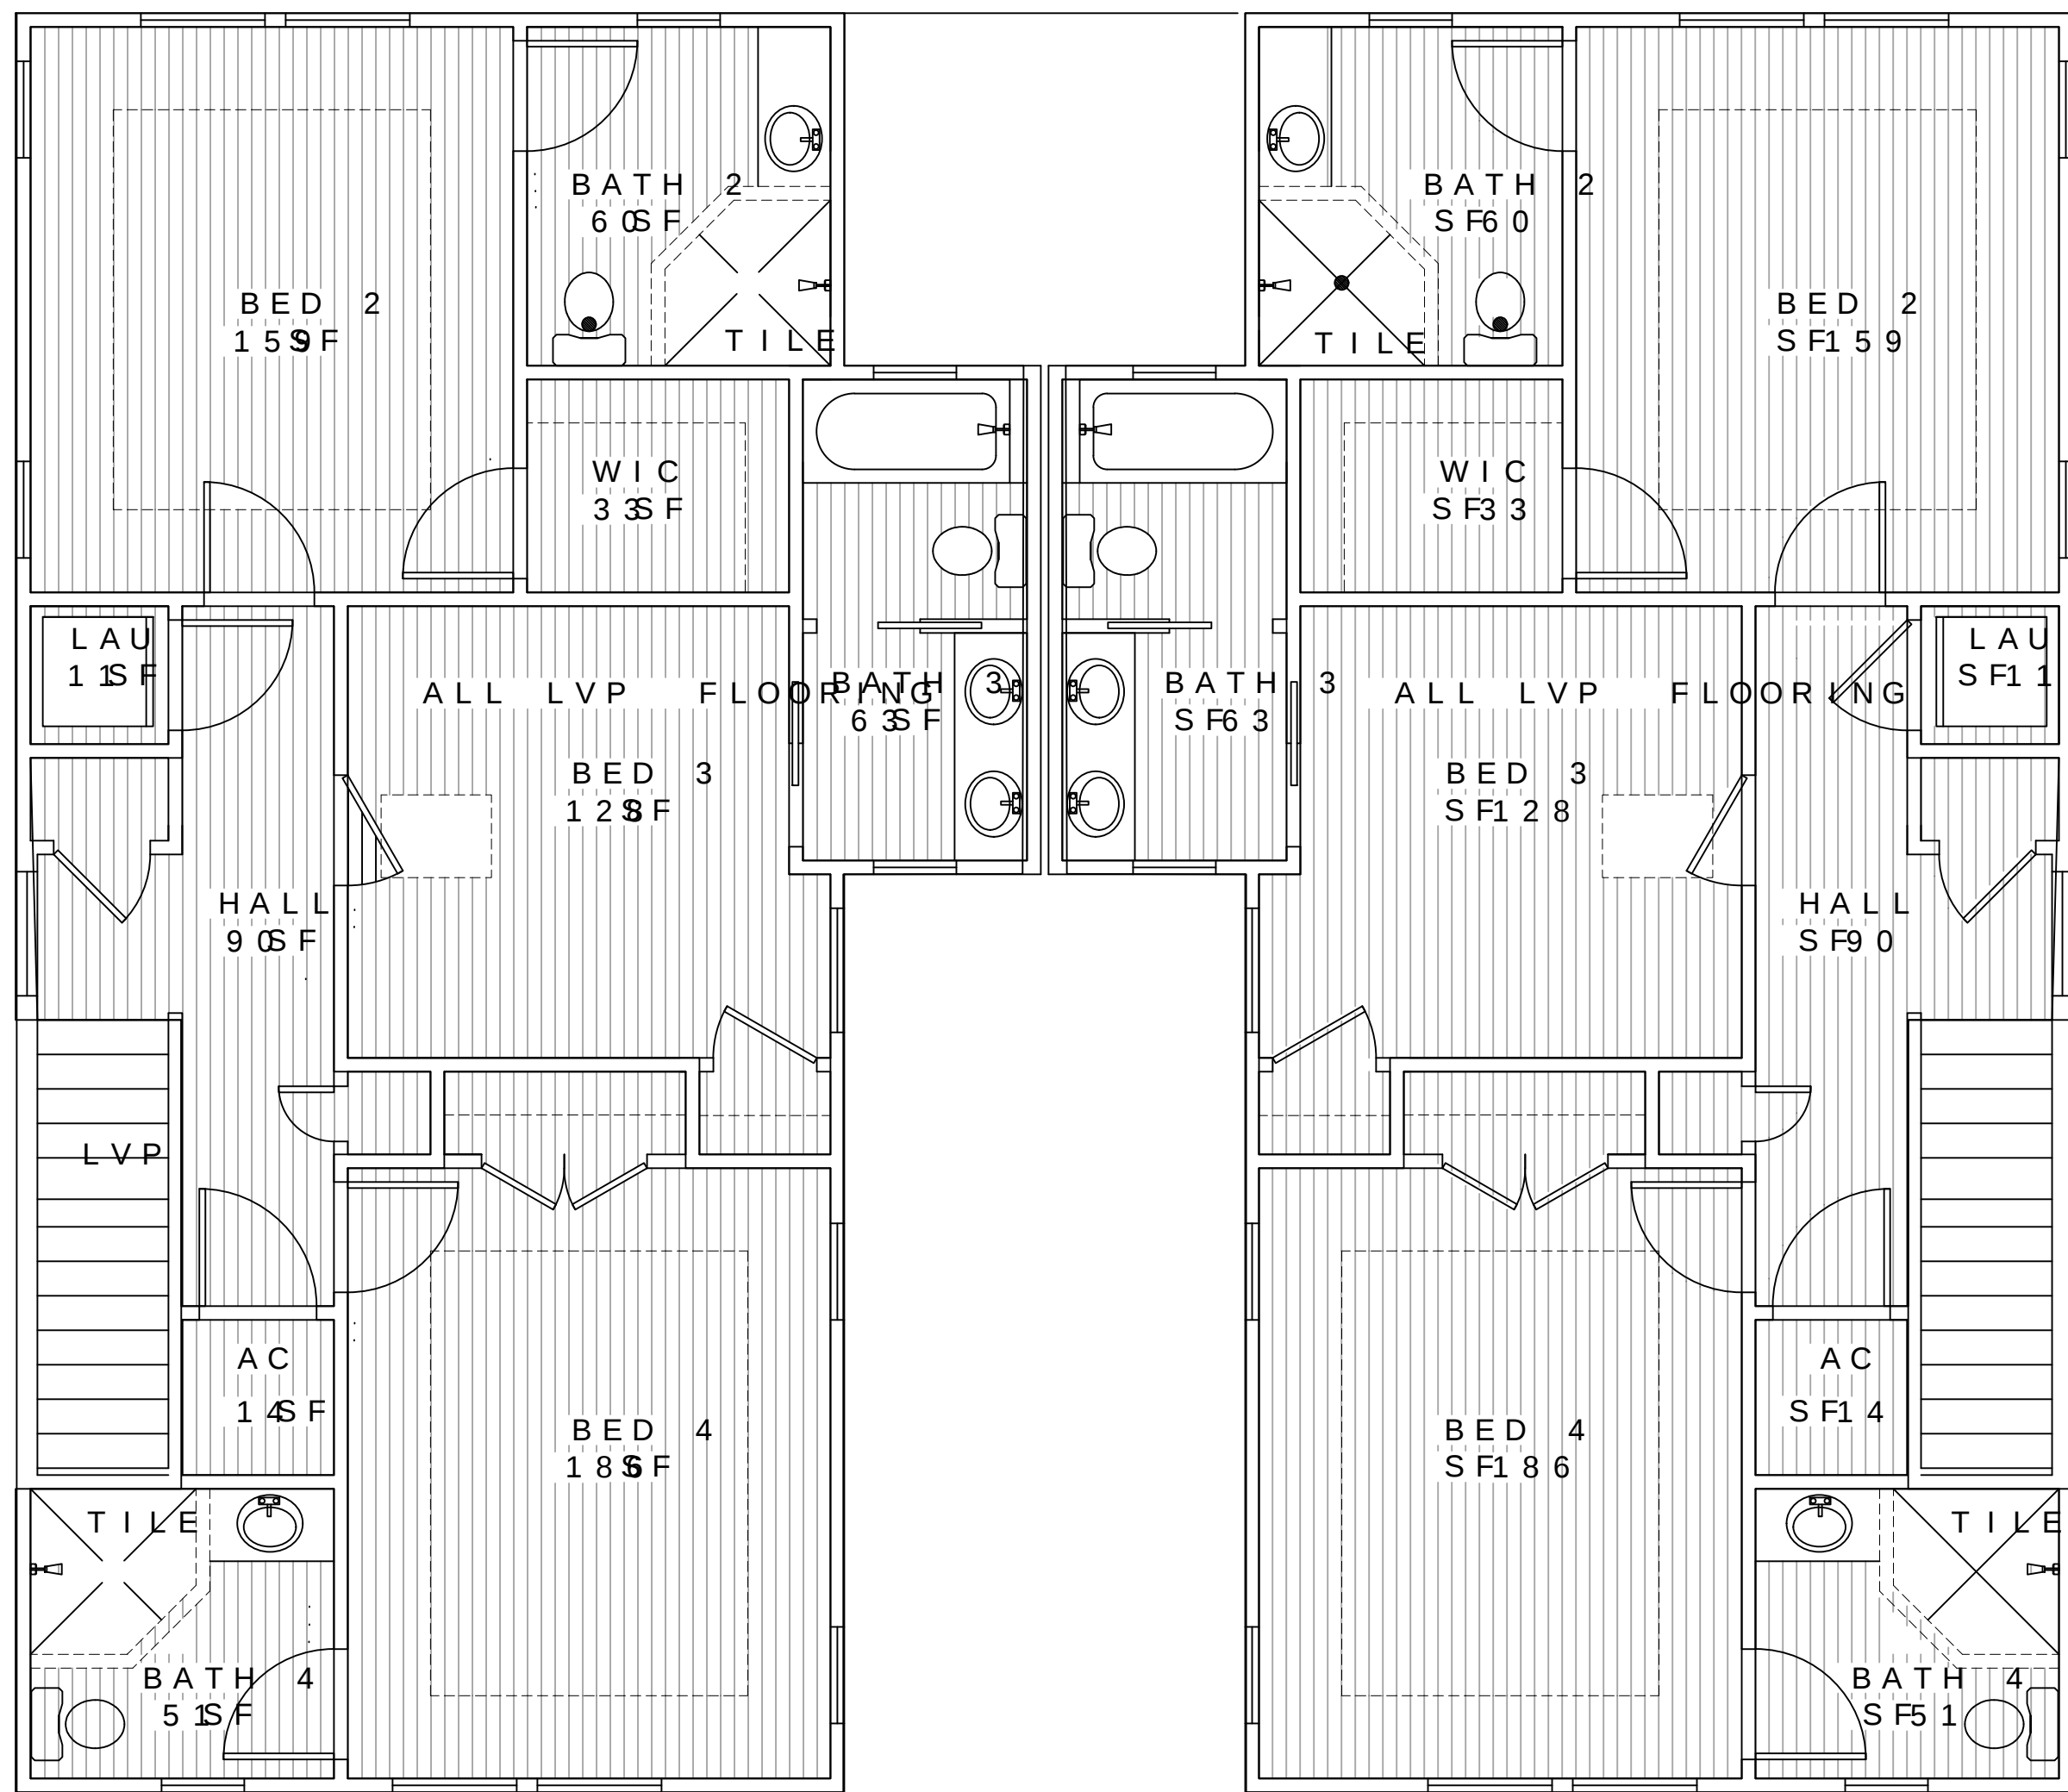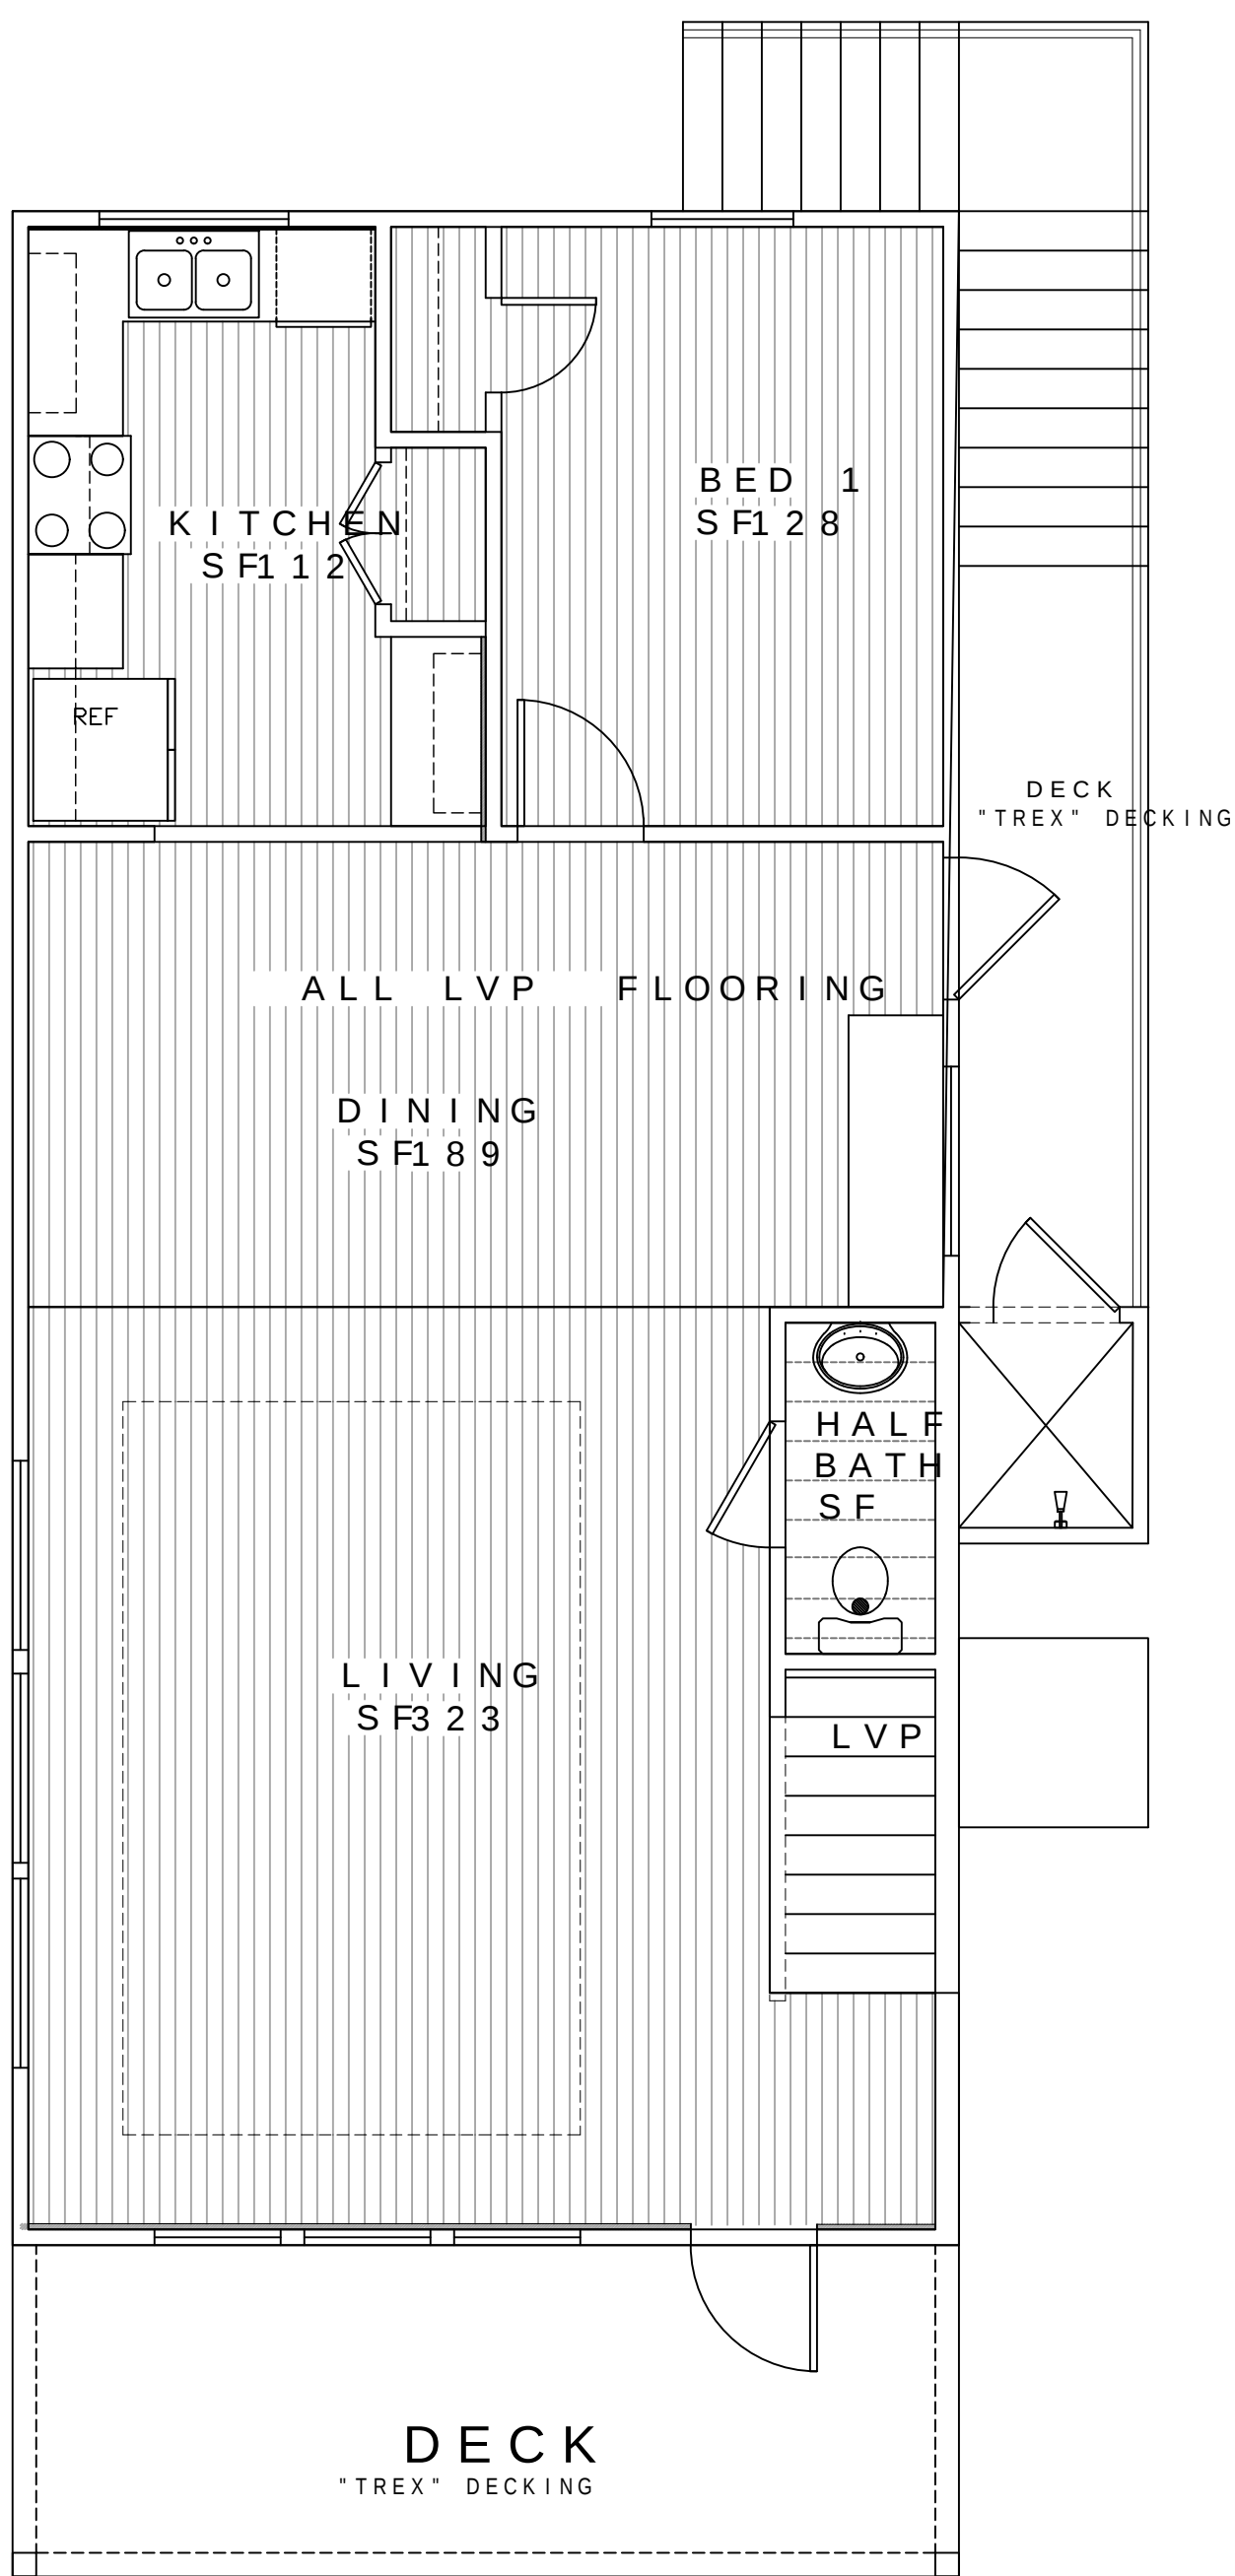


FLOORING PLAN
UPPER LEVEL

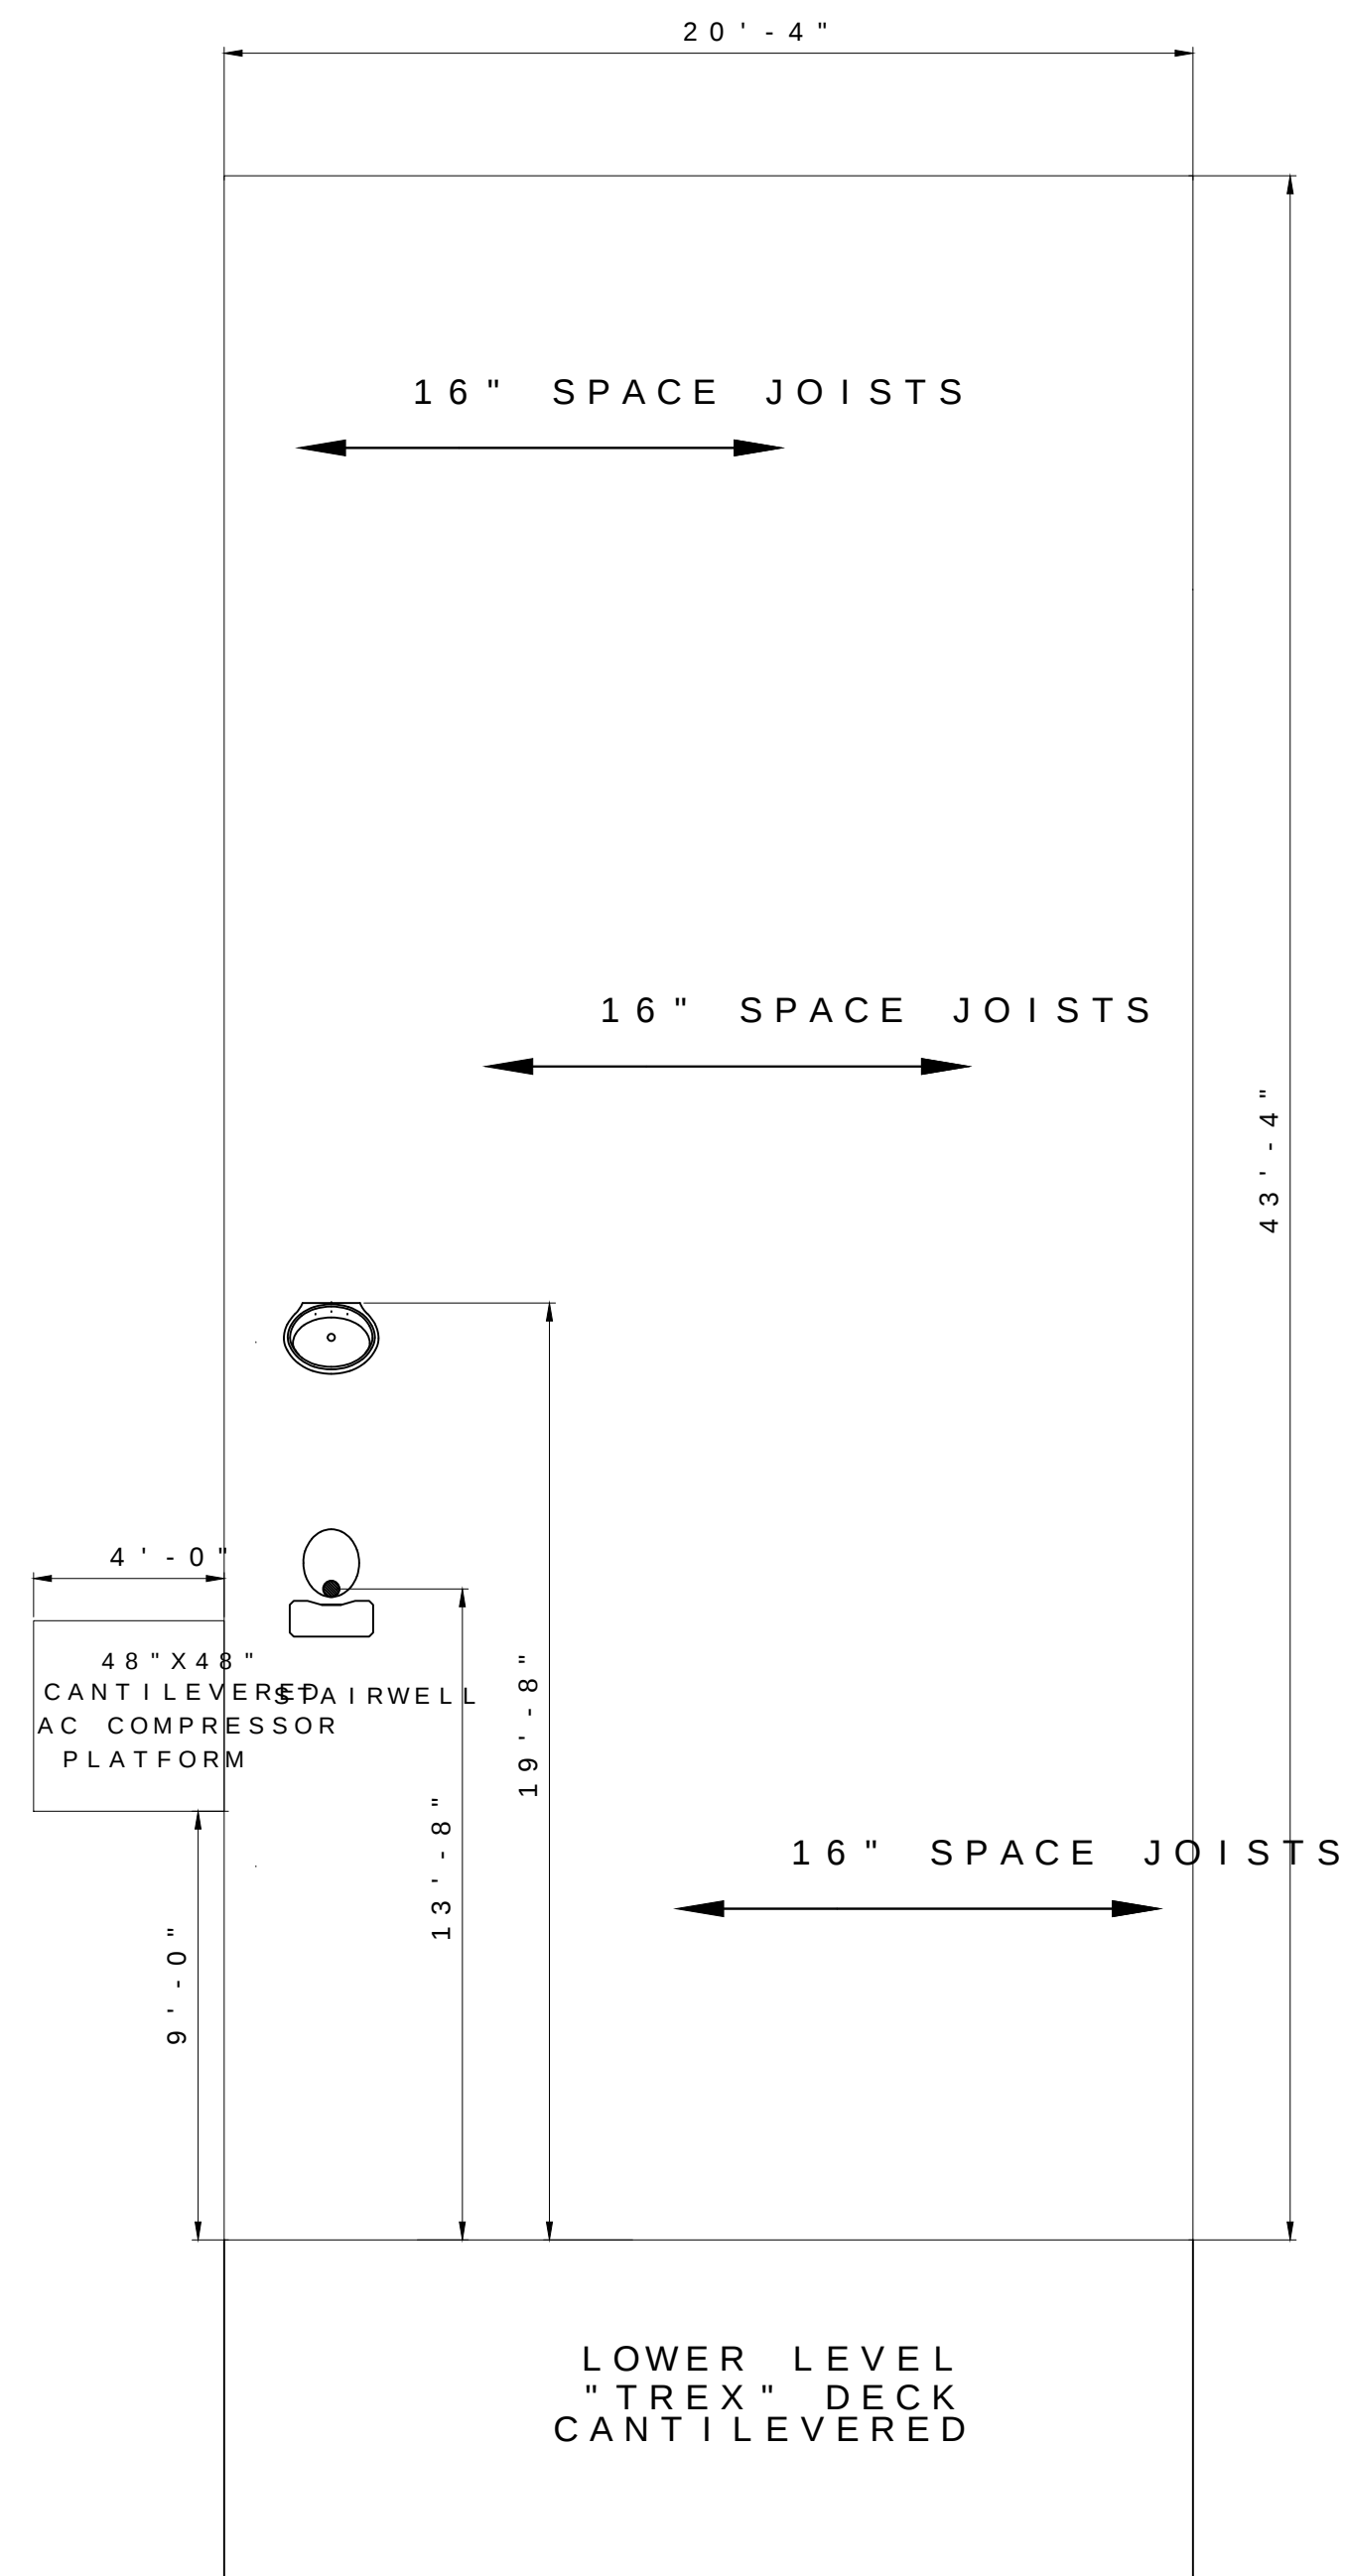

UPPER FLOOR FRAMING
SCALE: 1/4"=1'-0"

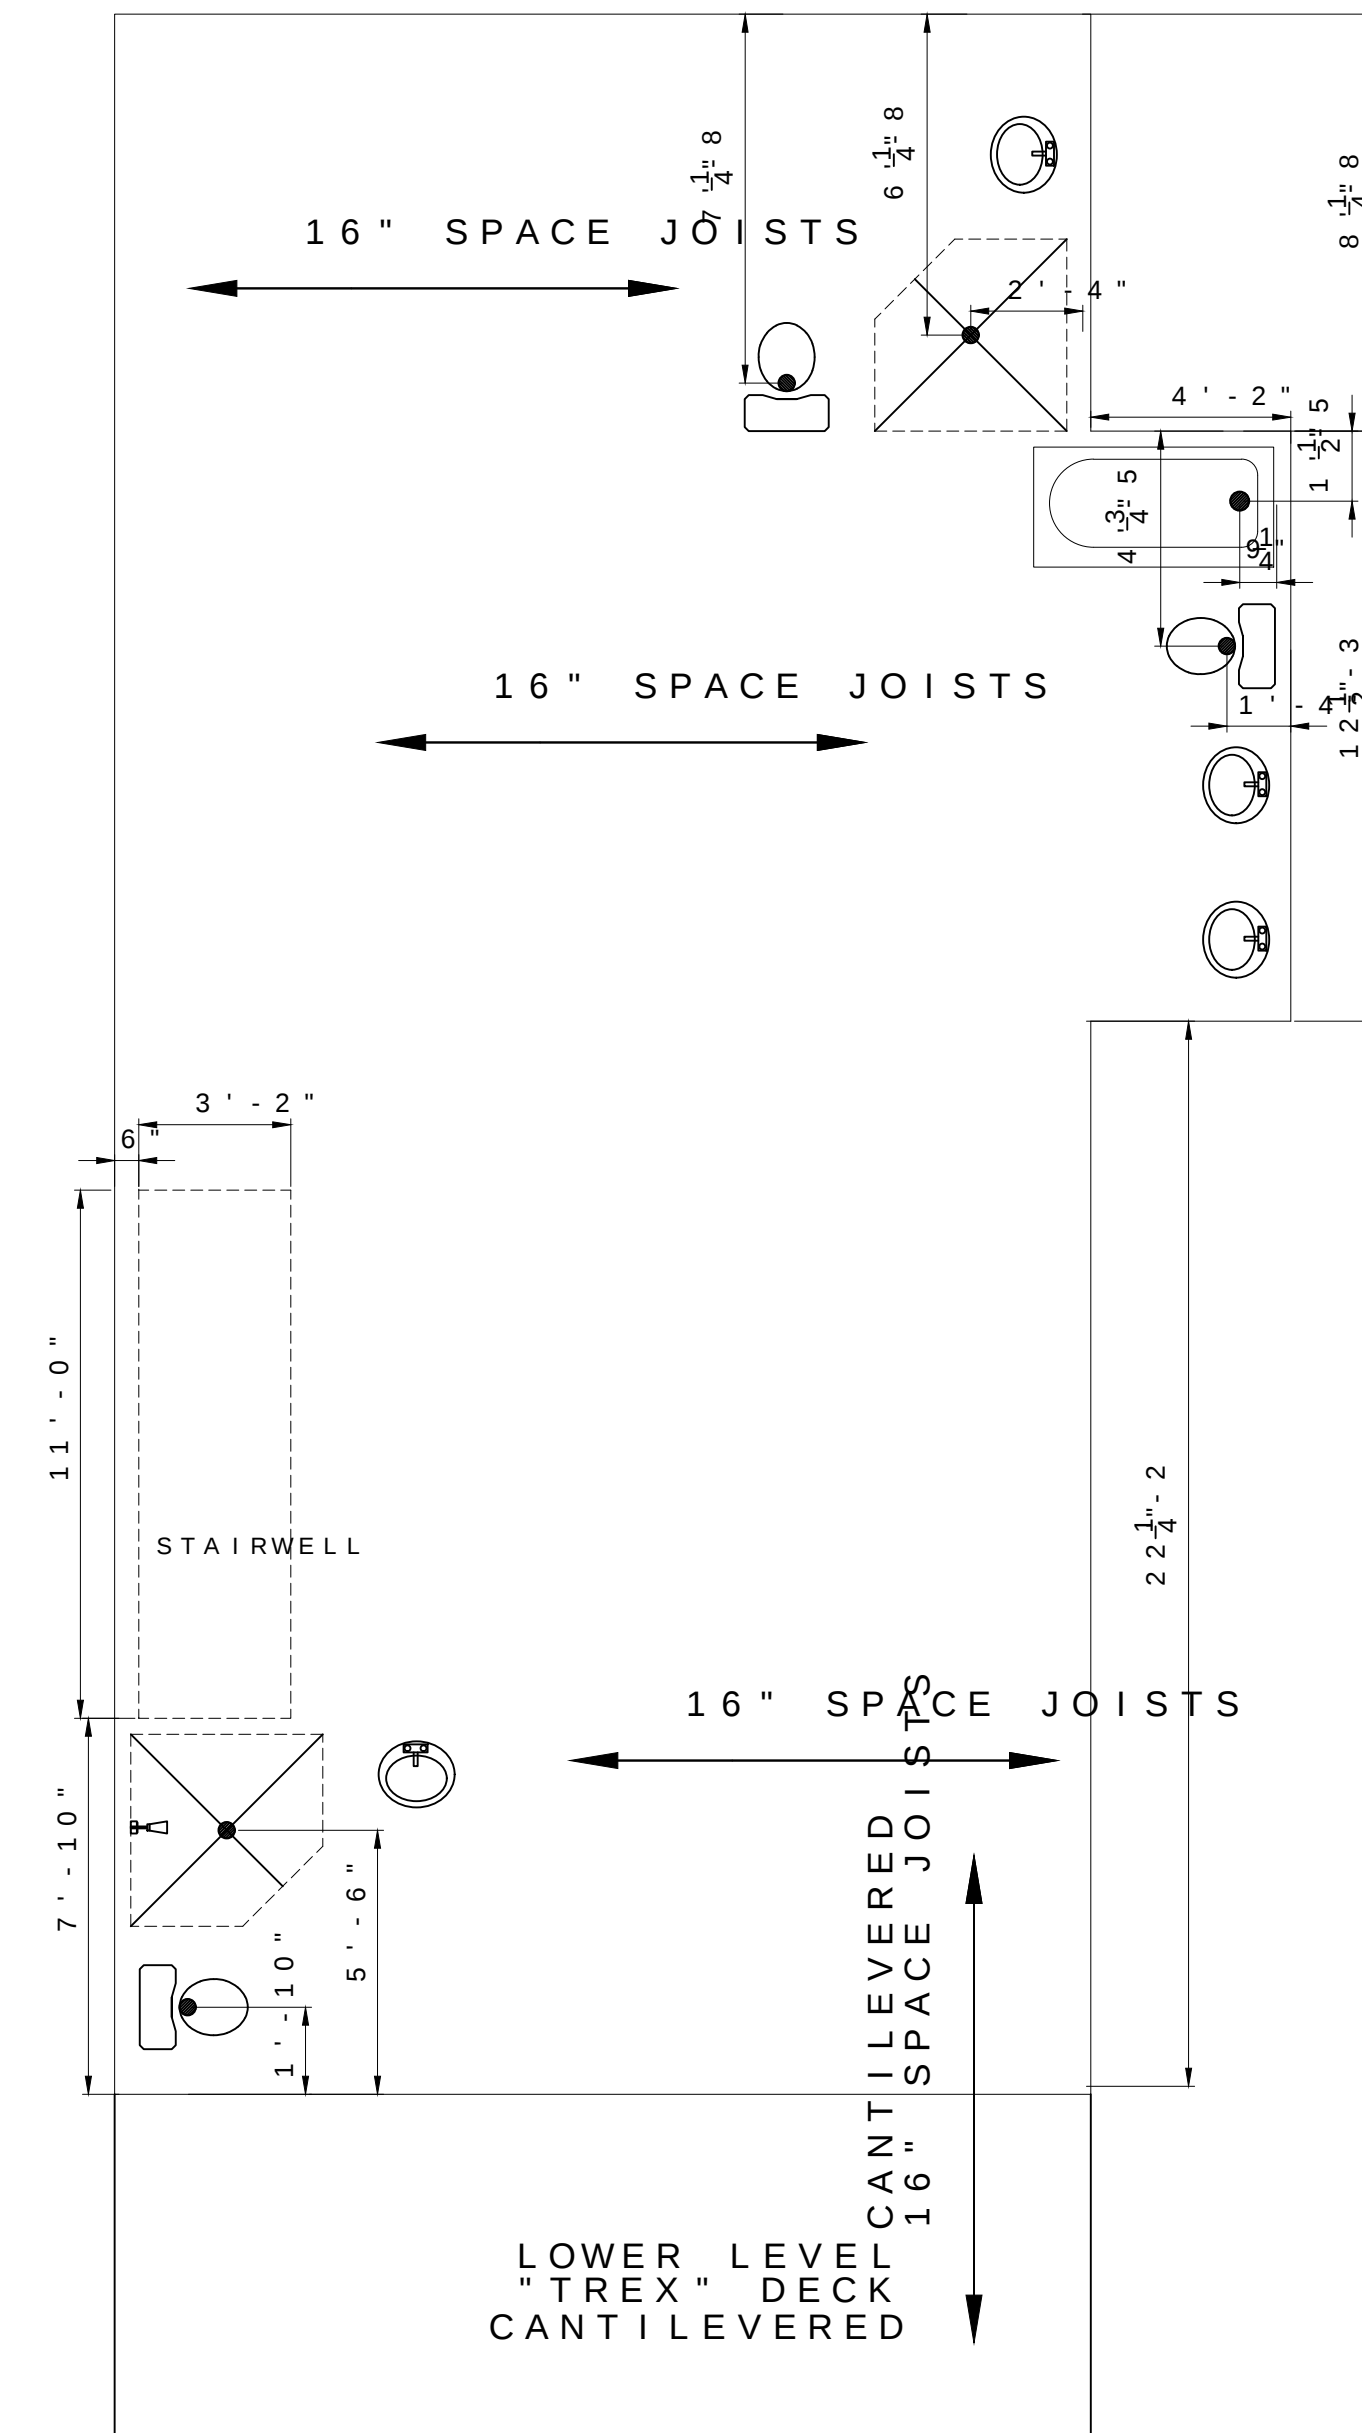

UPPER FLOOR FRAMING
SCALE: 1/4"=1'-0"

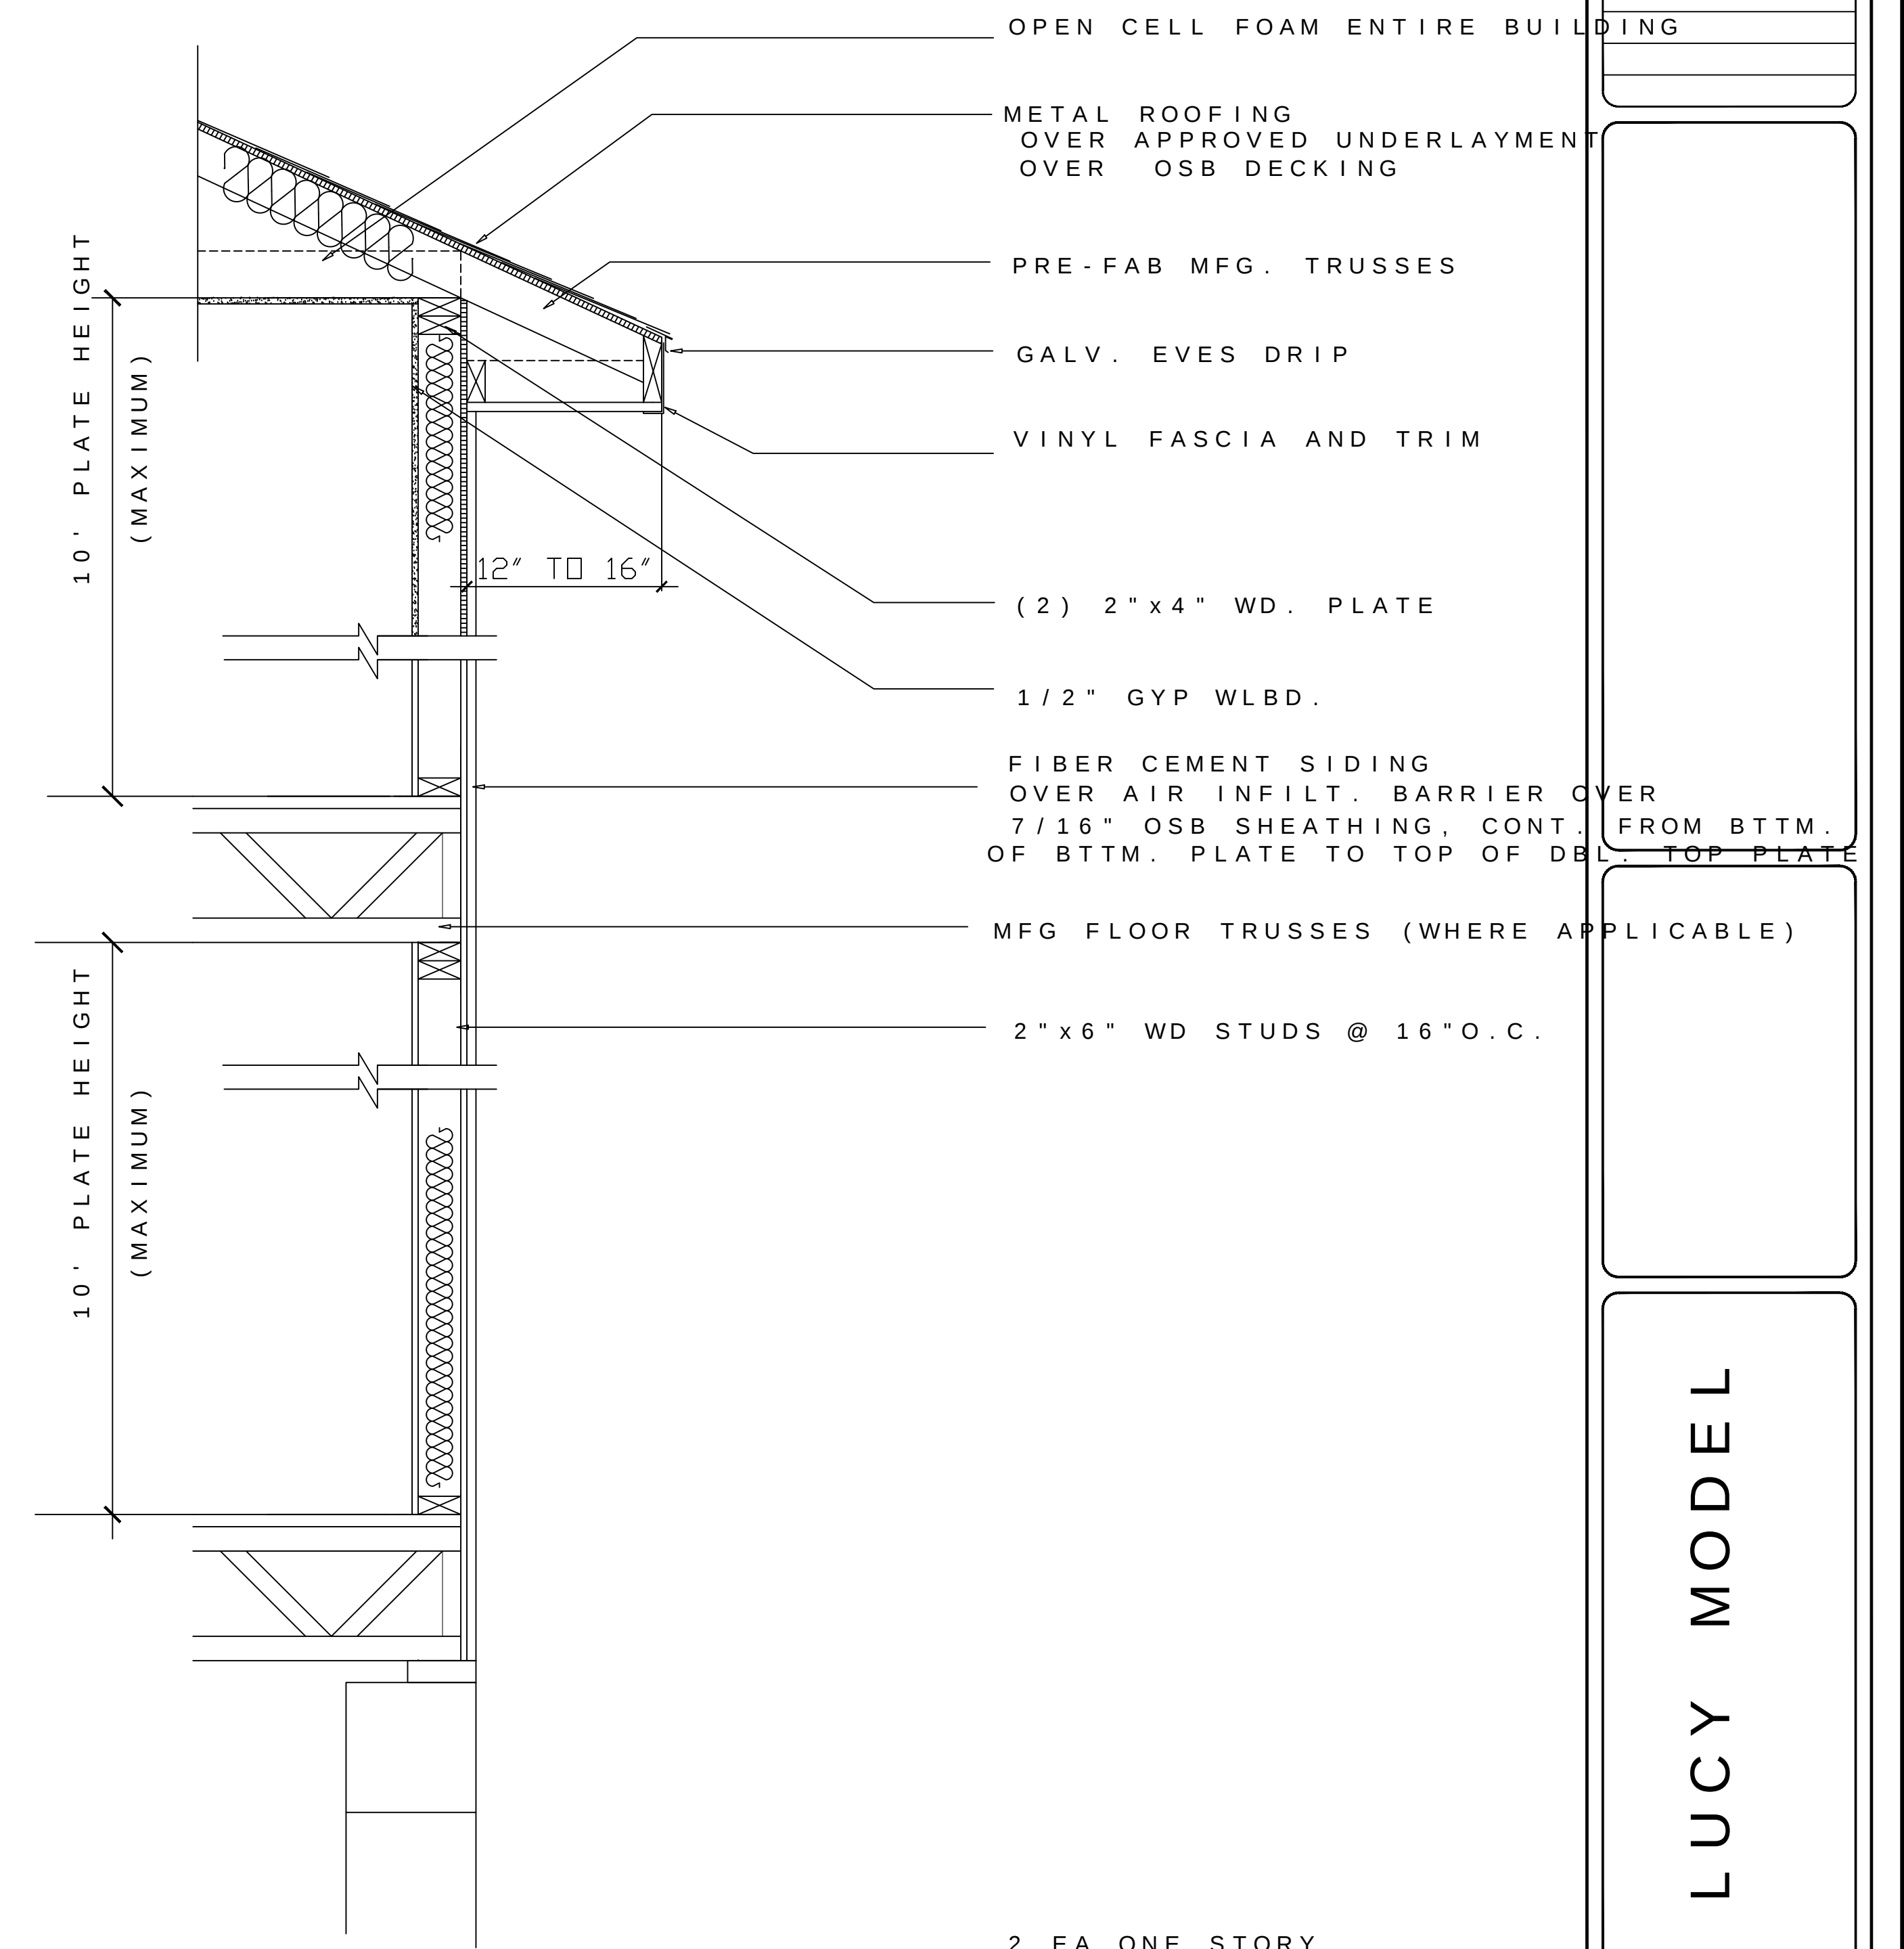

2 EA ONE STORY
TYPICAL WALL SECTION
A

DESCRIPTION

DRAWN BY: W. RICHARDSON

DATE: 11-18-2021

SHEET: 7
OF 7

LUCY MODEL